






 






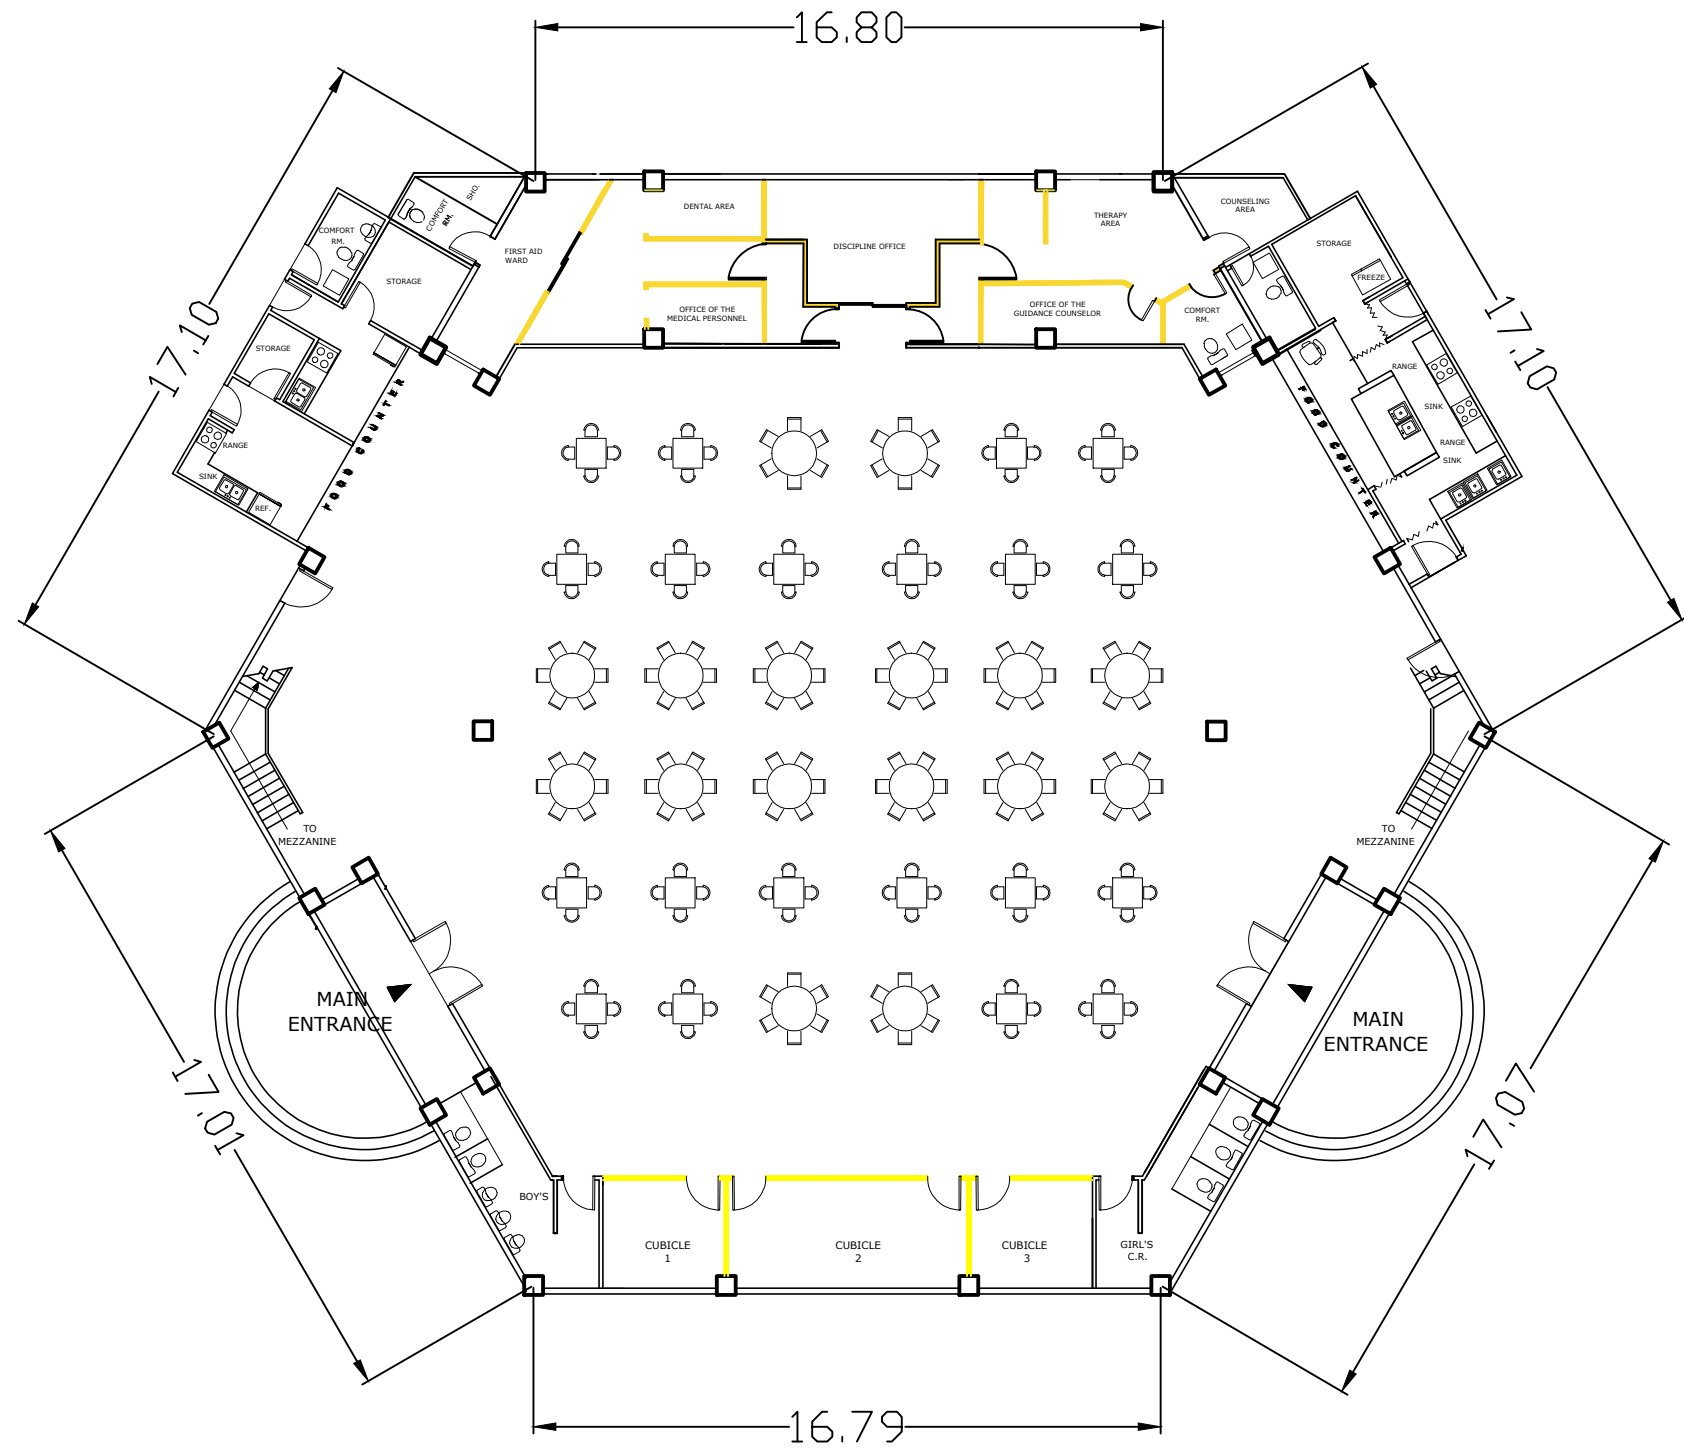


# LEGEND & SYMBOLS


-  — EXHAUST AIR GRILLES
-  — FRESH AIR GRILLES
-  — TROFFER LIGHT  
CEILING MOUNTED  
*(Supply and install by the contractor @ Phase 1)*
-  — DOUBLE GIMBAL LIGHT
-  — CHANDILIER
-  — LED PINLIGHT  
*(Supply and install by the contractor @ Phase 1)*
-  — SQUARE TYPE RECESSED LED LIGHT
-  — CYLINDRICAL PORCELAIN LIGHT
-  — EMERGENCY LIGHT
-  — FIRE SPRINKLER
-  — SMOKE DETECTOR
-  — CEILING MOUNTED SPEAKER
-  — FLOOR OUTLET
-  — DRYWALL PARTITION



Note:

1. This drawing is for contractor reference.
2. Specification of fixtures shall be approved by the owner, contractor shall submit their specification for during design phase for approval.


**GROUND FLOOR PLAN**  
 Scale 1:1

|  |   |  |                                      |   |                |           |
|--|---|--|--------------------------------------|---|----------------|-----------|
| OWNER:   | Project Title:  | Prepared by:   | Recommending approval by:            | Approved by:                                  | Sheet Content: | Sheet No. |
|  Republic of the Philippines<br>DEPARTMENT OF SCIENCE AND TECHNOLOGY<br>Philippine Science High School<br>MIMAROPA Region Campus<br>Brgy. Rizal, Odiongan, Romblon 5505 | <b>Design and Build Scheme Infrastructure Project:<br/>         Completion of School Canteen and<br/>         Student Activity Center</b> | <u>Engr. Joseph G. Bantang</u><br>Resident Engineer, DBC | <u>Meriam F. Fallar</u><br>FAD Chief | <u>Edward C. Albaracin</u><br>Campus Director | As Shown       | A         |
|  | Location: Brgy. Rizal, Odiongan Romblon 5505  | Date Prepared: November 19, 2019                         | Date: November 19, 2019              | Date: November 19, 2019                       | 0              | 1         |