

 
 



 











LEGEND & SYMBOLS

-  — EXHAUST AIR GRILLES
-  — FRESH AIR GRILLES
-  — TROFFER LIGHT
CEILING MOUNTED
(Supply and install by the contractor @ Phase 1)
-  — DOUBLE GIMBAL LIGHT
-  — CHANDILIER
-  — LED PINLIGHT
(Supply and install by the contractor @ Phase 1)
-  — SQUARE TYPE RECESSED LED LIGHT
-  — CYLINDRICAL PORCELAIN LIGHT
-  — EMERGENCY LIGHT
-  — FIRE SPRINKLER
-  — SMOKE DETECTOR
-  — CEILING MOUNTED SPEAKER
-  — FLOOR OUTLET
-  — DRYWALL PARTITION




MEZZANINE FLOOR PLAN
 Scale _____ 1:1

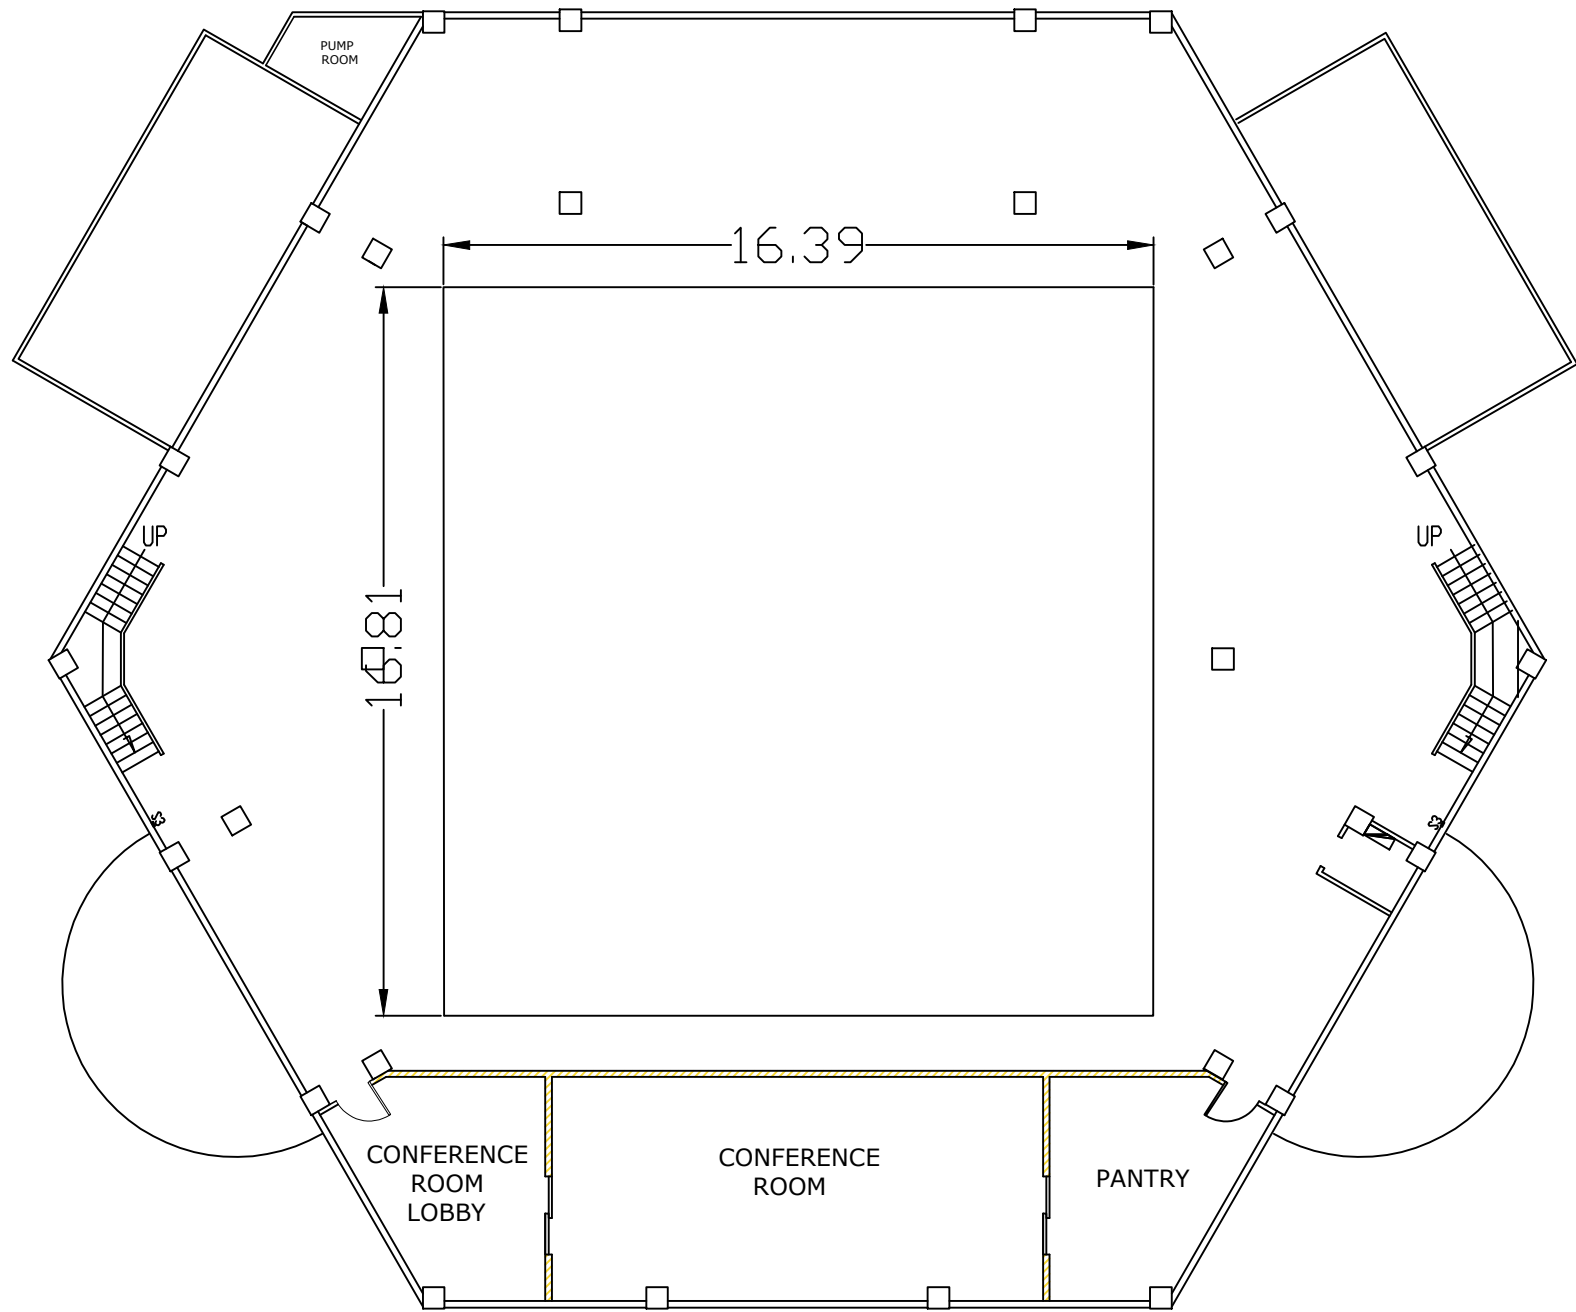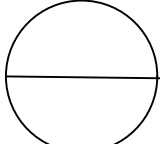- Note:**
1. This drawing is for contractor reference.
 2. Specification of fixtures shall be approved by the owner, contractor shall submit their specification for during design phase for approval.

OWNER:	Project Title:	Prepared by:	Recommending approval by:	Approved by:	Sheet Content:	Sheet No.
 Republic of the Philippines DEPARTMENT OF SCIENCE AND TECHNOLOGY Philippine Science High School MIMAROPA Region Campus Brgy. Rizal, Odiongan, Romblon 5505	Design and Build Scheme Infrastructure Project: Completion of School Canteen and Student Activity Center	<u>Engr. Jos. G. Bantang</u> Resident Engineer, DBC	<u>Meriam F. Fallar</u> FAD Chief	<u>Edward C. Albaracin</u> Campus Director	As Shown	A
	Location: Brgy. Rizal, Odiongan Romblon 5505	Date Prepared: November 19, 2019	Date: November 19, 2019	Date: November 19, 2019		0