



**GROUND FLOOR**  
**1**  
**FDAS LAYOUT**  
 EC 1 SCALE 1:150MTS

OWNER:	Project Title:	Prepared by:	Recommending approval by:	Approved by:	Sheet Content:	Sheet No.
<div style="font-size: 8px; margin-bottom: 5px;">..Pisay logo.jpg</div> Republic of the Philippines DEPARTMENT OF SCIENCE AND TECHNOLOGY Philippine Science High School MIMAROPA Region Campus Brgy. Rizal, Odiongan, Romblon 5505	<b>CONSTRUCTION OF DORMITORY BUILDING I</b>	<b>PLANNING TEAM</b>	<b>Meriam F. Fallar</b> FAD Chief	<b>Edward C. Albaracin</b> Campus Director	As Shown	EC
	Location: Brgy. Rizal, Odiongan Romblon 5505	Date Prepared:	Date:	Date:	1	10

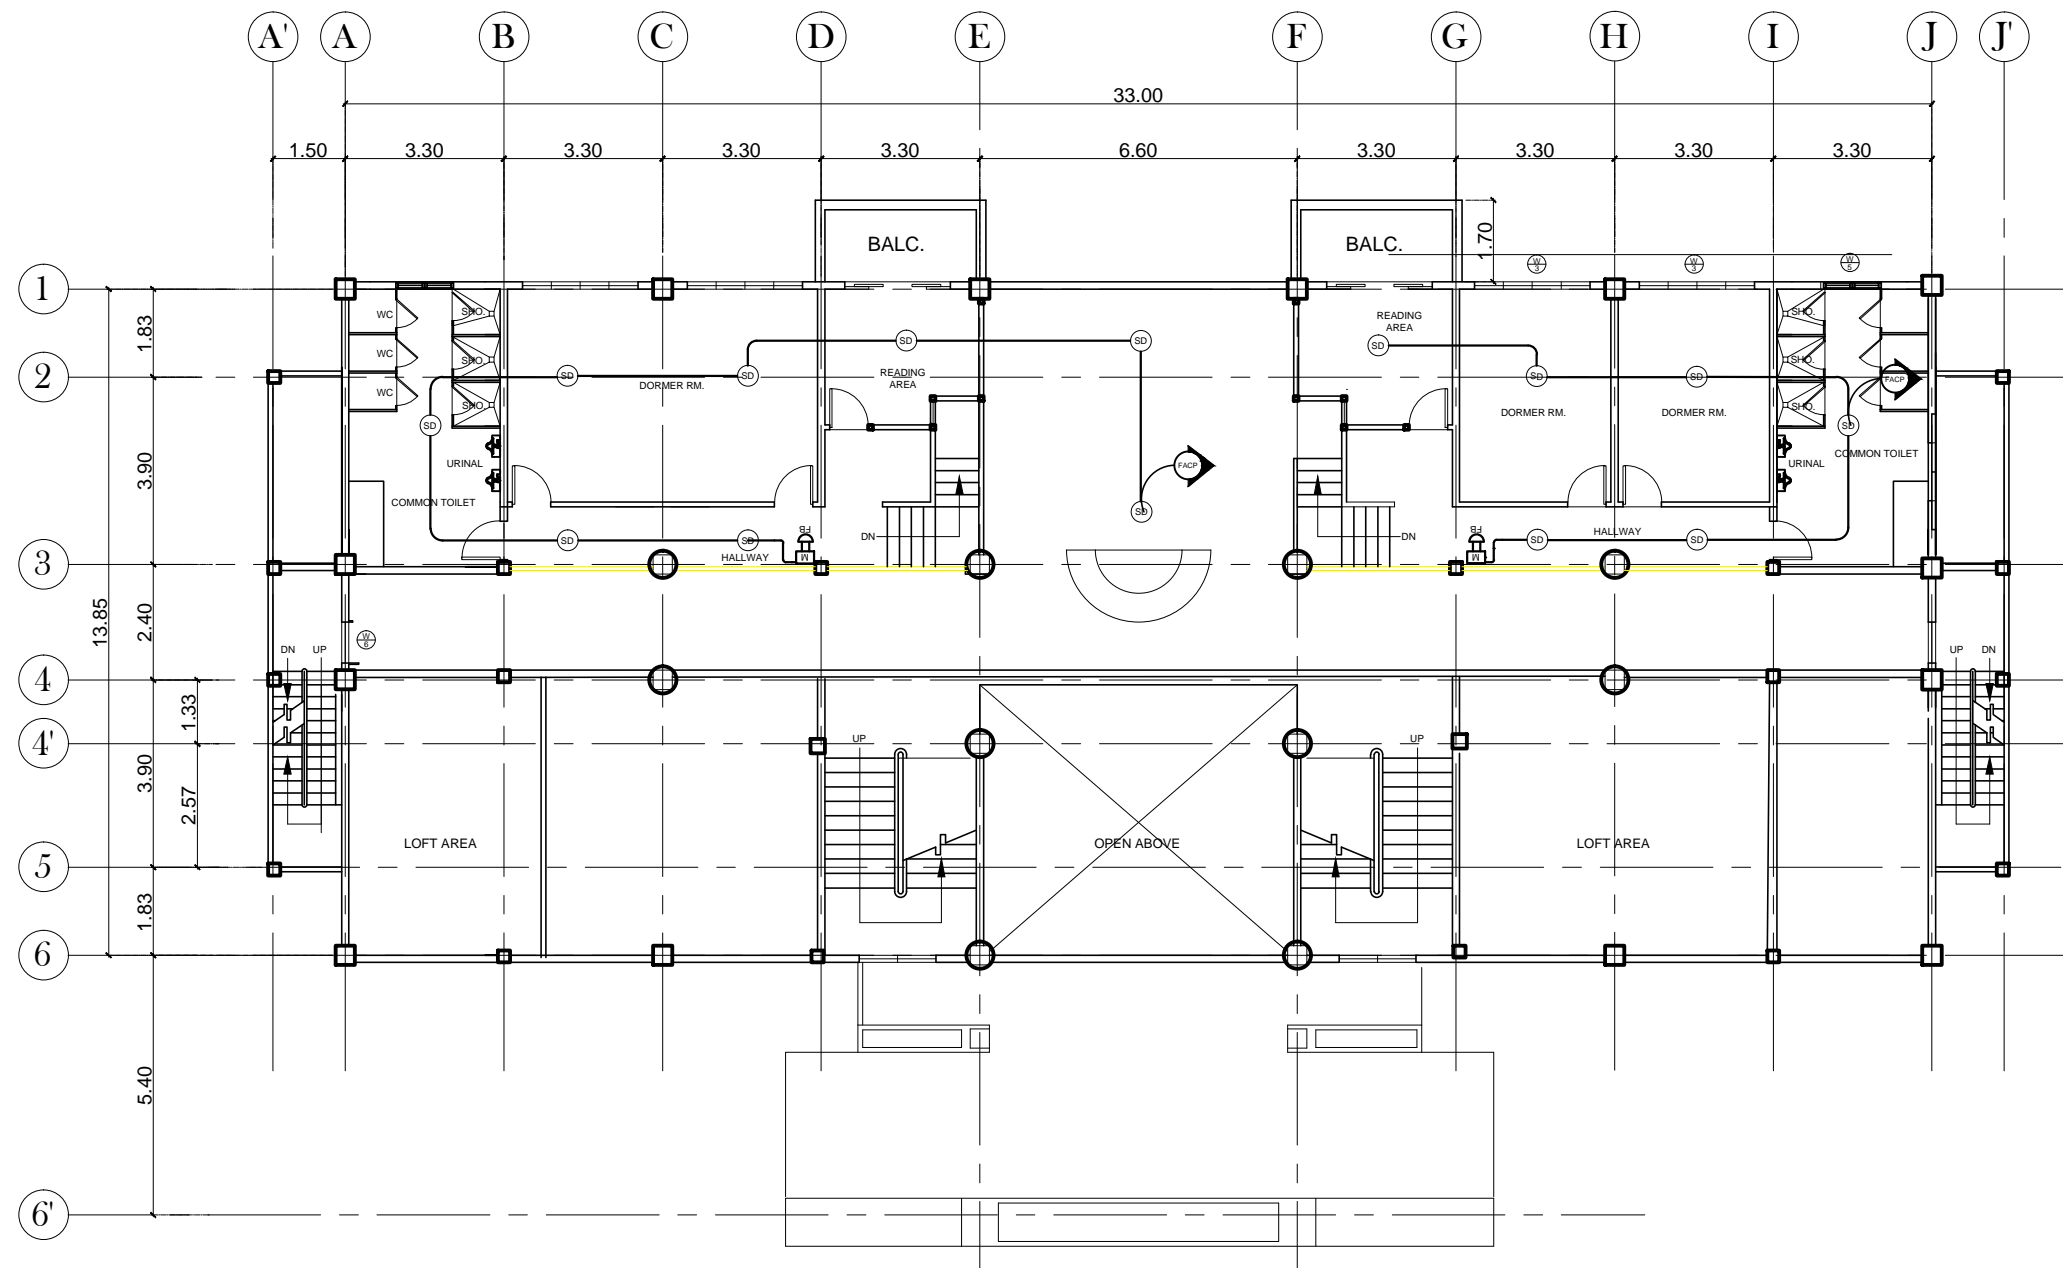


MEZZANINE FLOOR  
1  
EC 2 **FDAS LAYOUT**

OWNER:	Project Title:	Prepared by:	Recommending approval by:	Approved by:	Sheet Content:	Sheet No.
 Republic of the Philippines DEPARTMENT OF SCIENCE AND TECHNOLOGY Philippine Science High School MIMAROPA Region Campus Brgy. Rizal, Odiongan, Romblon 5505	<b>CONSTRUCTION OF DORMITORY BUILDING I</b>	<u>PLANNING TEAM</u>	<u>Meriam F. Fallar</u> FAD Chief	<u>Edward C. Albaracin</u> Campus Director	As Shown	EC
	Location: Brgy. Rizal, Odiongan Romblon 5505	Date Prepared:	Date:	Date:	2	10

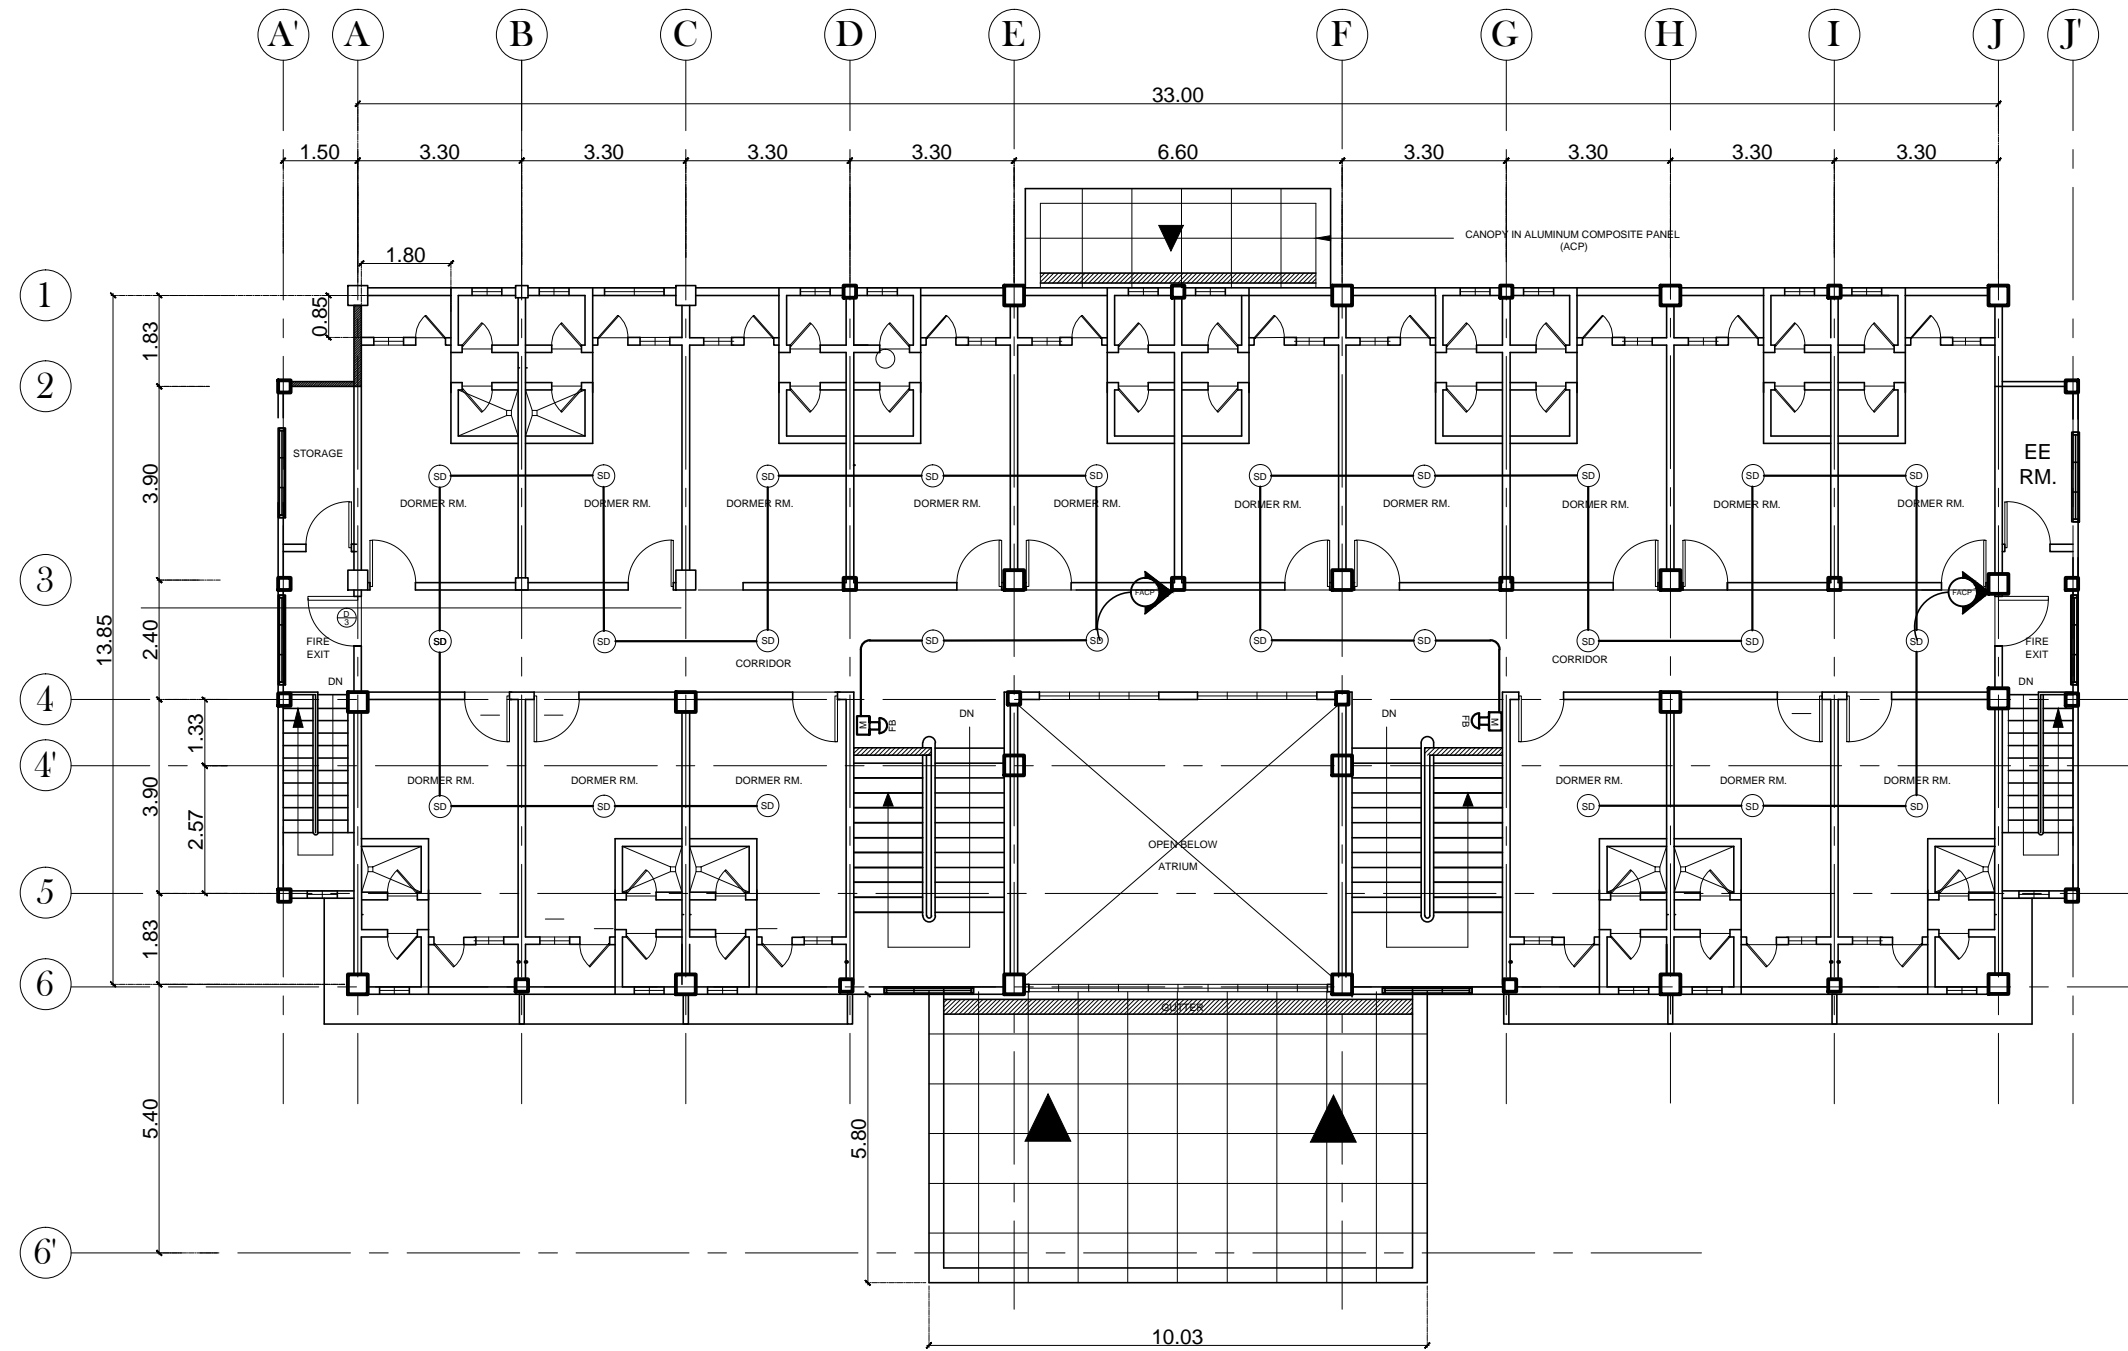


**SECOND FLOOR**  
**1 FDAS LAYOUT**  
 EC 3 SCALE 1:150MTS

OWNER:	Project Title:	Prepared by:	Recommending approval by:	Approved by:	Sheet Content:	Sheet No.
Republic of the Philippines DEPARTMENT OF SCIENCE AND TECHNOLOGY Philippine Science High School MIMAROPA Region Campus Brgy. Rizal, Odiongan, Romblon 5505	<b>CONSTRUCTION OF DORMITORY BUILDING I</b>	<b>PLANNING TEAM</b>	<b>Meriam F. Fallar</b> FAD Chief	<b>Edward C. Albaracin</b> Campus Director	As Shown	EC
	Location: Brgy. Rizal, Odiongan Romblon 5505	Date Prepared:	Date:	Date:	Date:	3   10

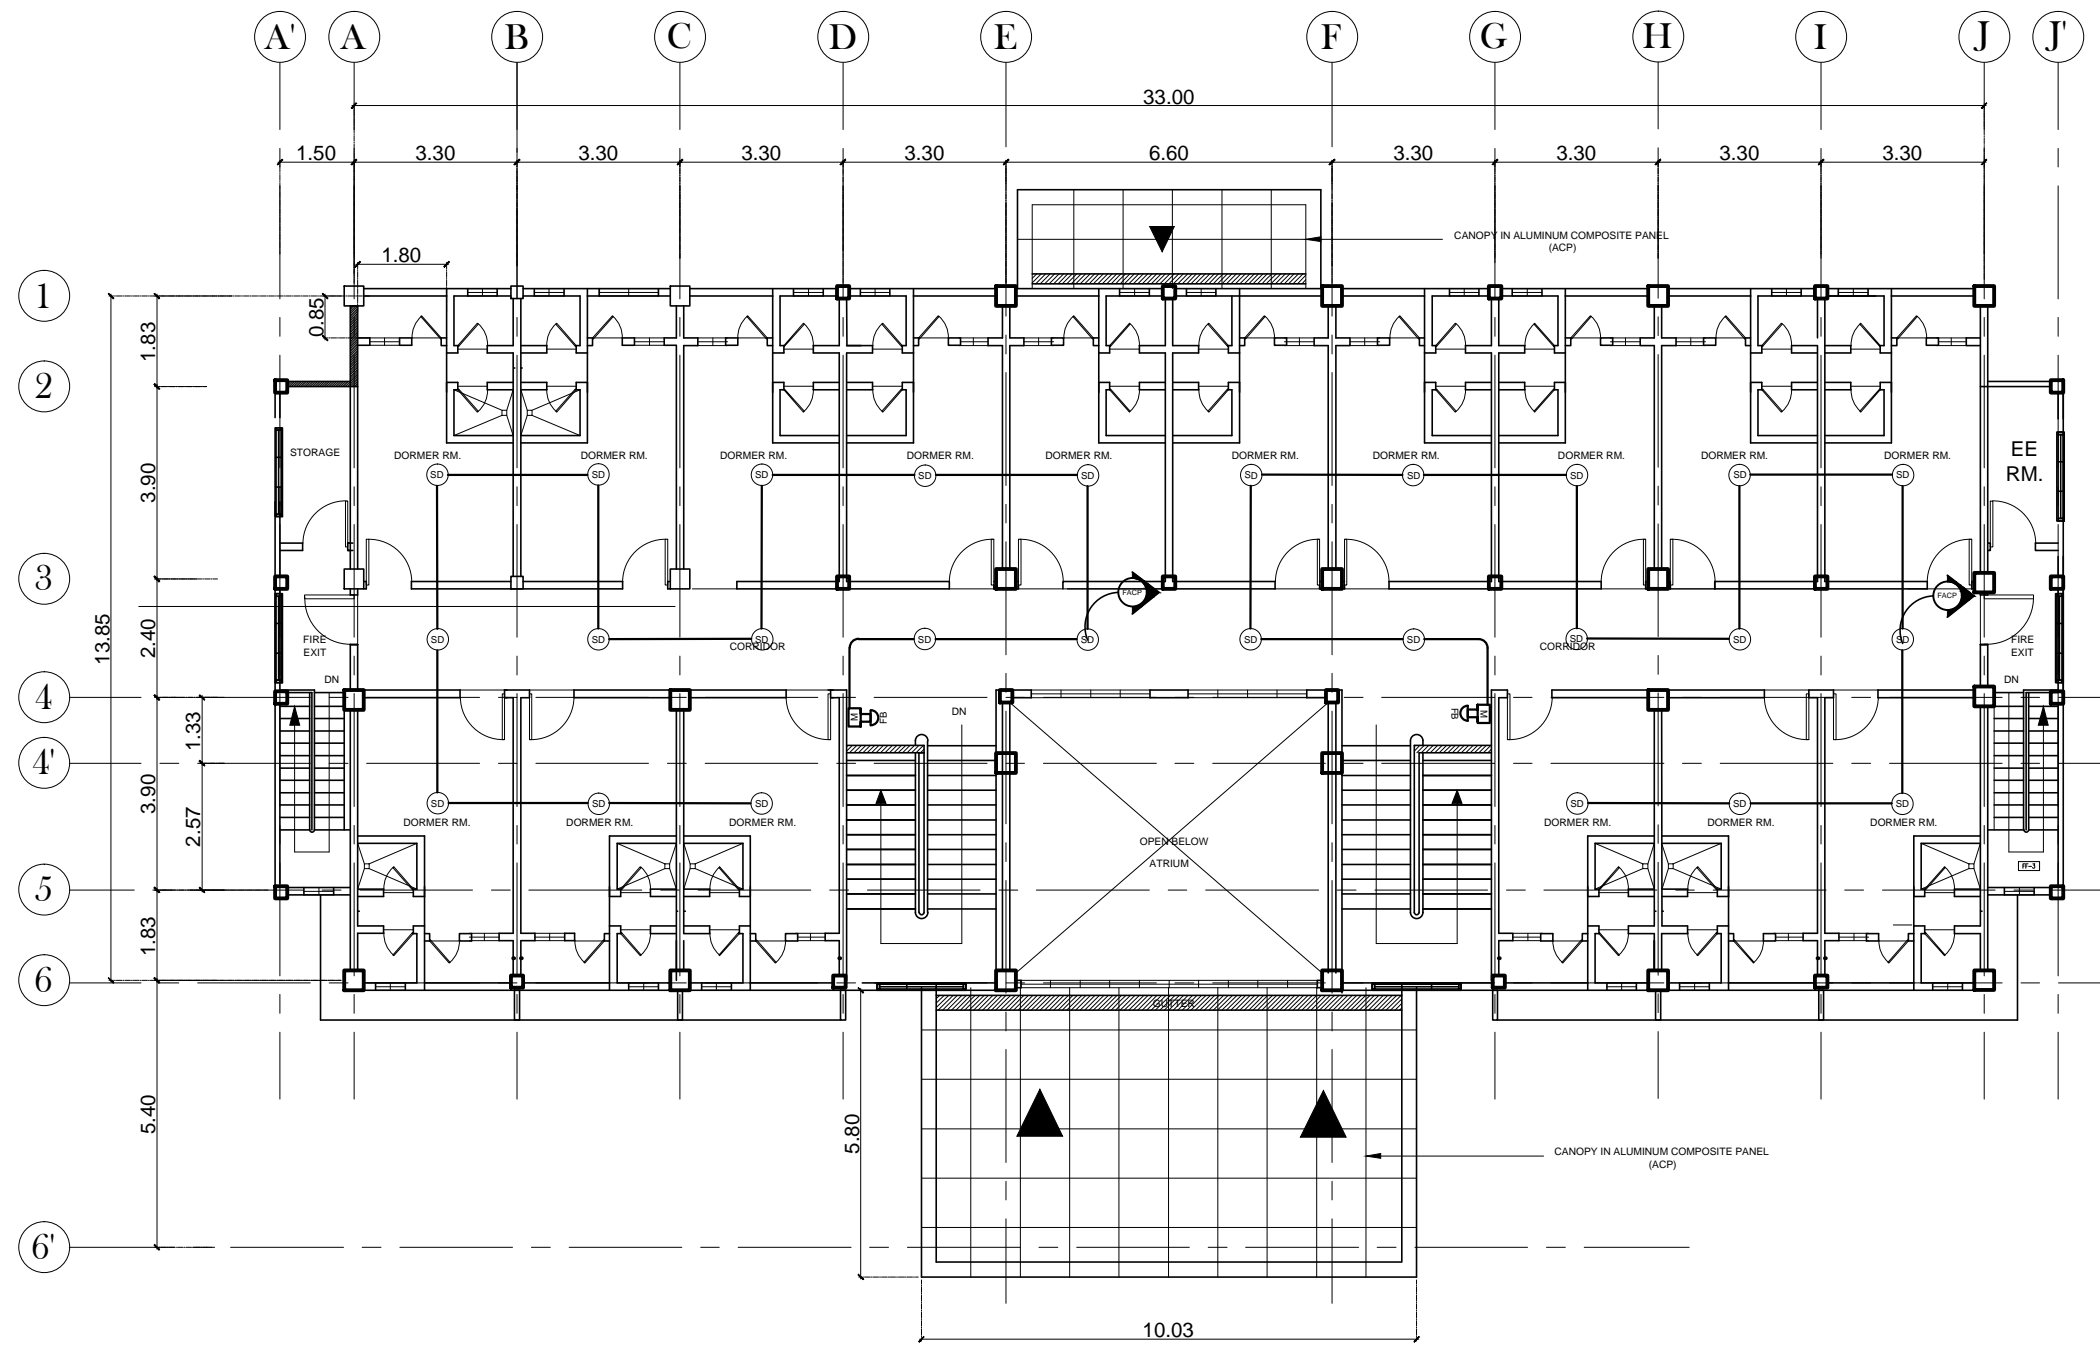

1  
**THIRD FLOOR**  
**EDAS LAYOUT**  
 EC 4 SCALE 1:150MTS

OWNER:	Project Title:	Prepared by:	Recommending approval by:	Approved by:	Sheet Content:	Sheet No.
<div style="border: 1px solid black; padding: 2px; font-size: 8px;">           ..\Pisay logo.jpg         </div> Republic of the Philippines DEPARTMENT OF SCIENCE AND TECHNOLOGY Philippine Science High School MIMAROPA Region Campus Brgy. Rizal, Odiongan, Romblon 5505	<b>CONSTRUCTION OF DORMITORY BUILDING I</b>	<u>PLANNING TEAM</u>	<u>Meriam F. Fallar</u> FAD Chief	<u>Edward C. Albaracin</u> Campus Director	As Shown	EC
	Location: Brgy. Rizal, Odiongan Romblon 5505	Date Prepared:	Date:	Date:		4   10

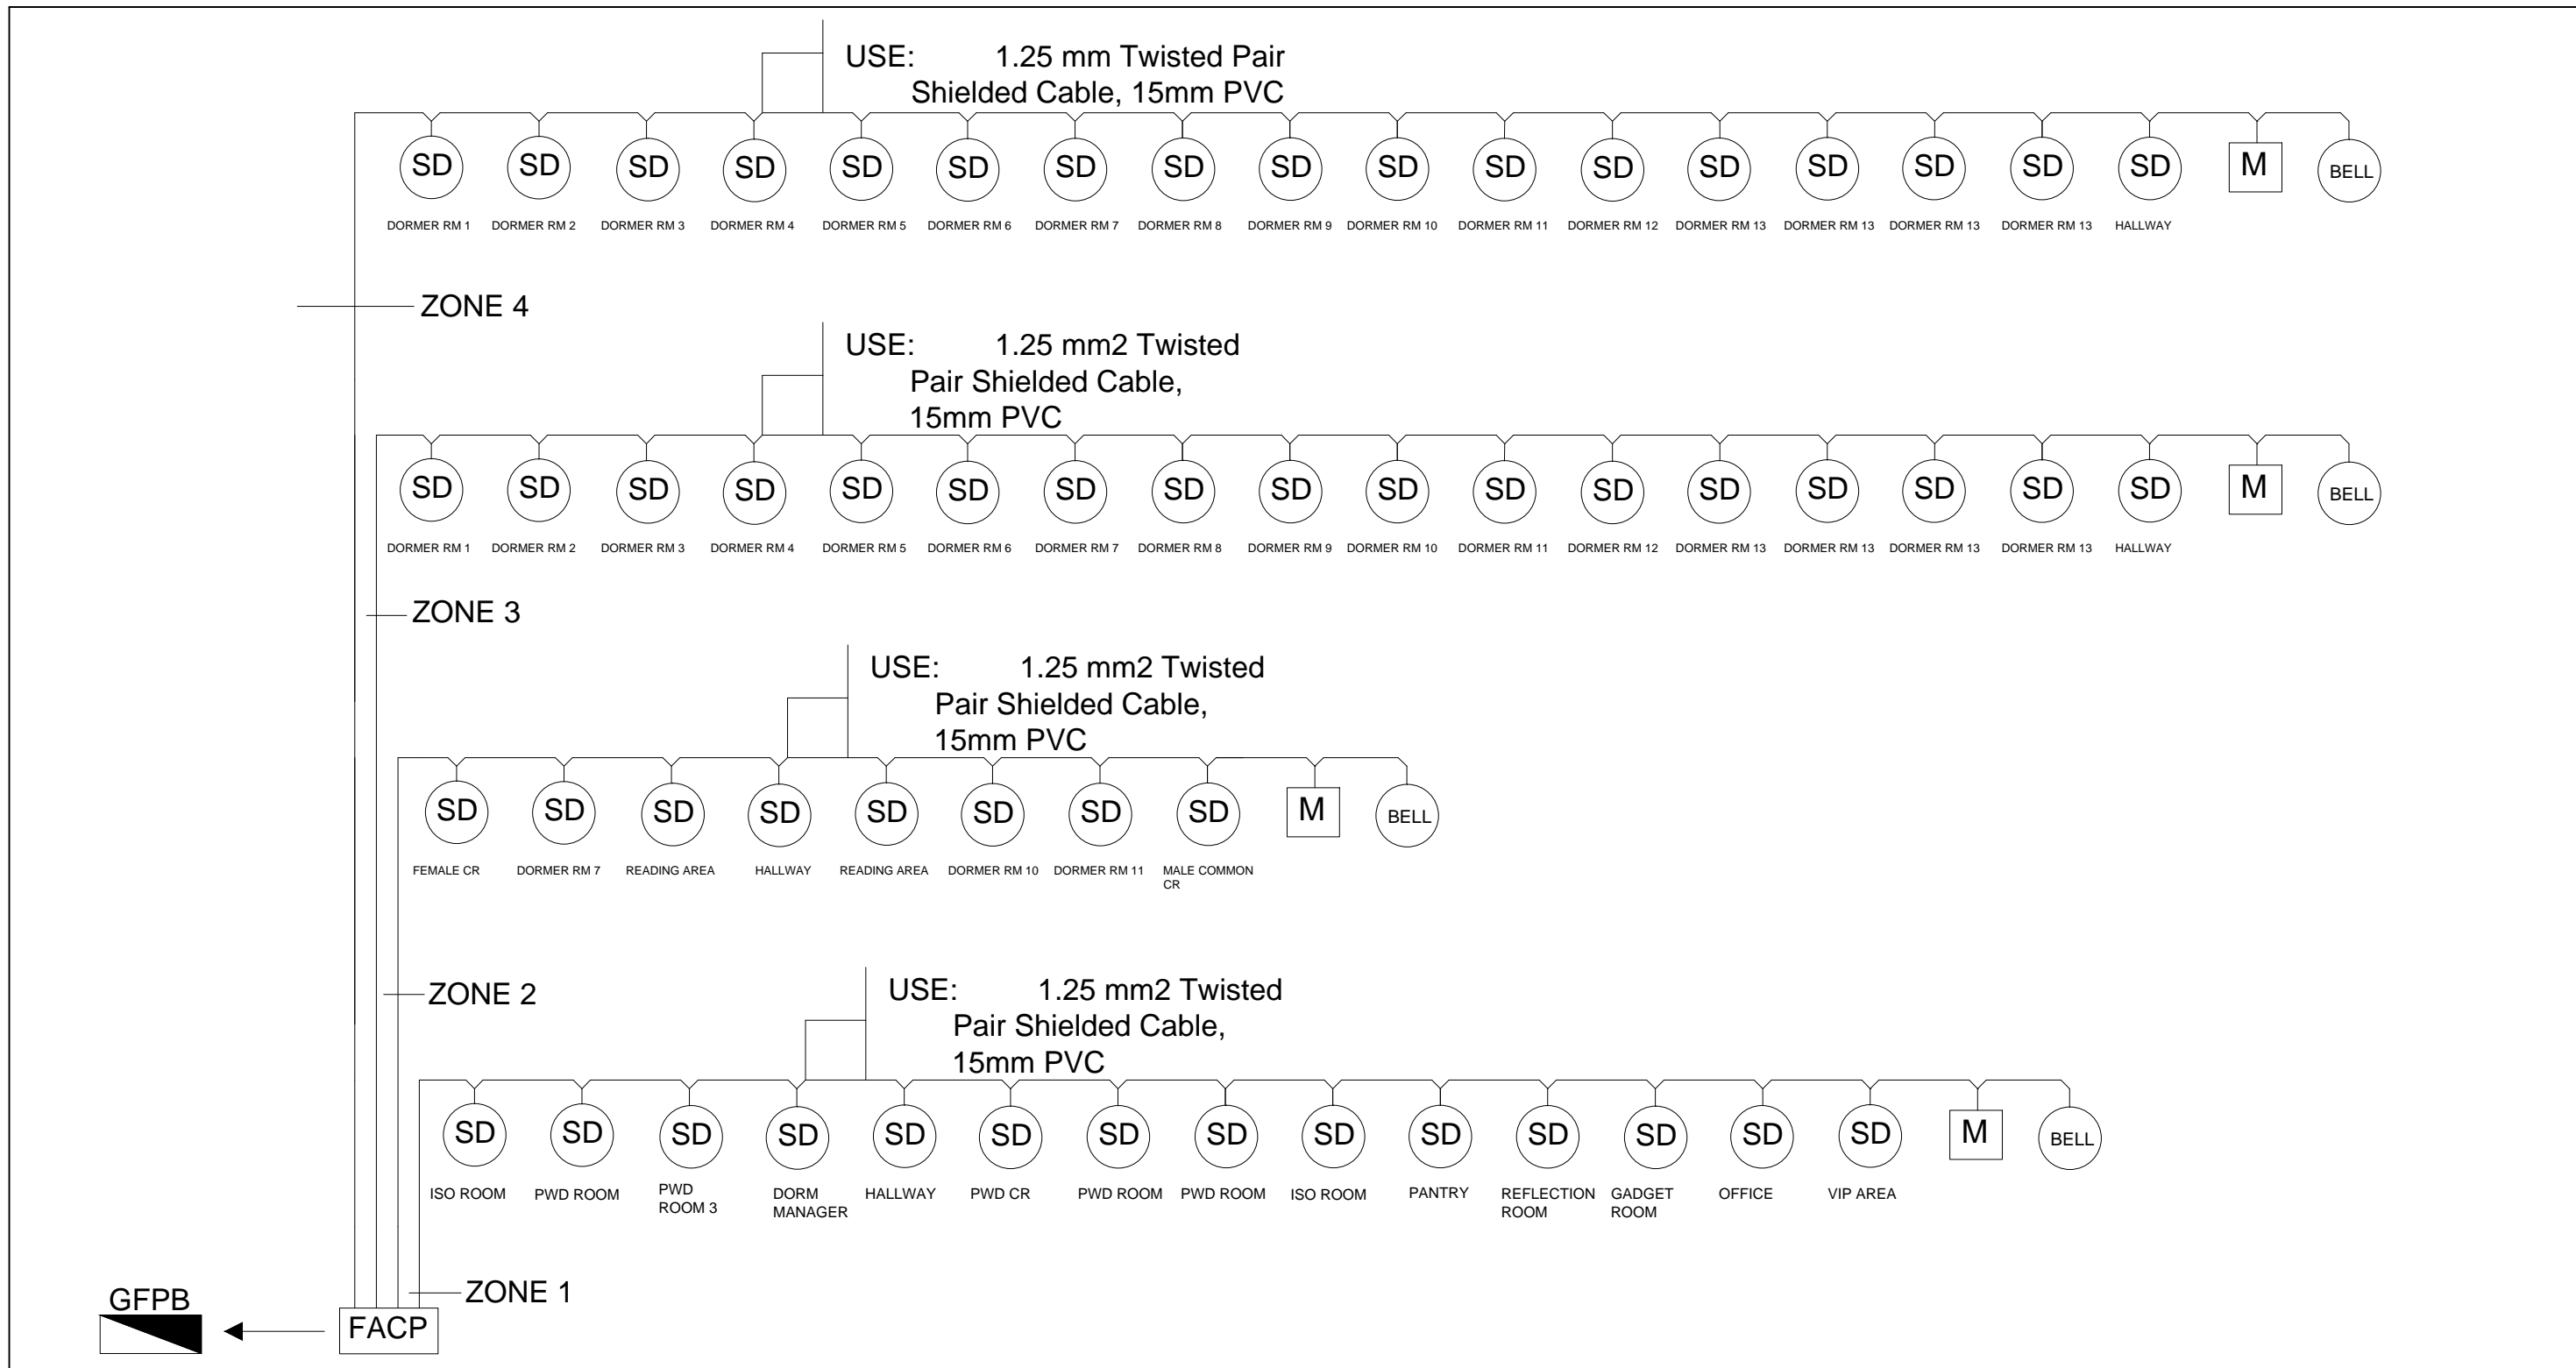


# FIRE ALARM AND DETECTION SYSTEM RISER DIAGRAM

1  
EC 5

SCALE


1:150MTS

OWNER:	Project Title:	Prepared by:	Recommending approval by:	Approved by:	Sheet Content:	Sheet No.
Republic of the Philippines DEPARTMENT OF SCIENCE AND TECHNOLOGY Philippine Science High School MIMAROPA Region Campus Brgy. Rizal, Odiongan, Romblon 5505	<b>CONSTRUCTION OF DORMITORY BUILDING I</b>	<u>PLANNING TEAM</u>	<u>Meriam F. Fallar</u> FAD Chief	<u>Edward C. Albaracin</u> Campus Director	As Shown	EC
	Location: Brgy. Rizal, Odiongan Romblon 5505	Date Prepared:	Date:	Date:		5   10

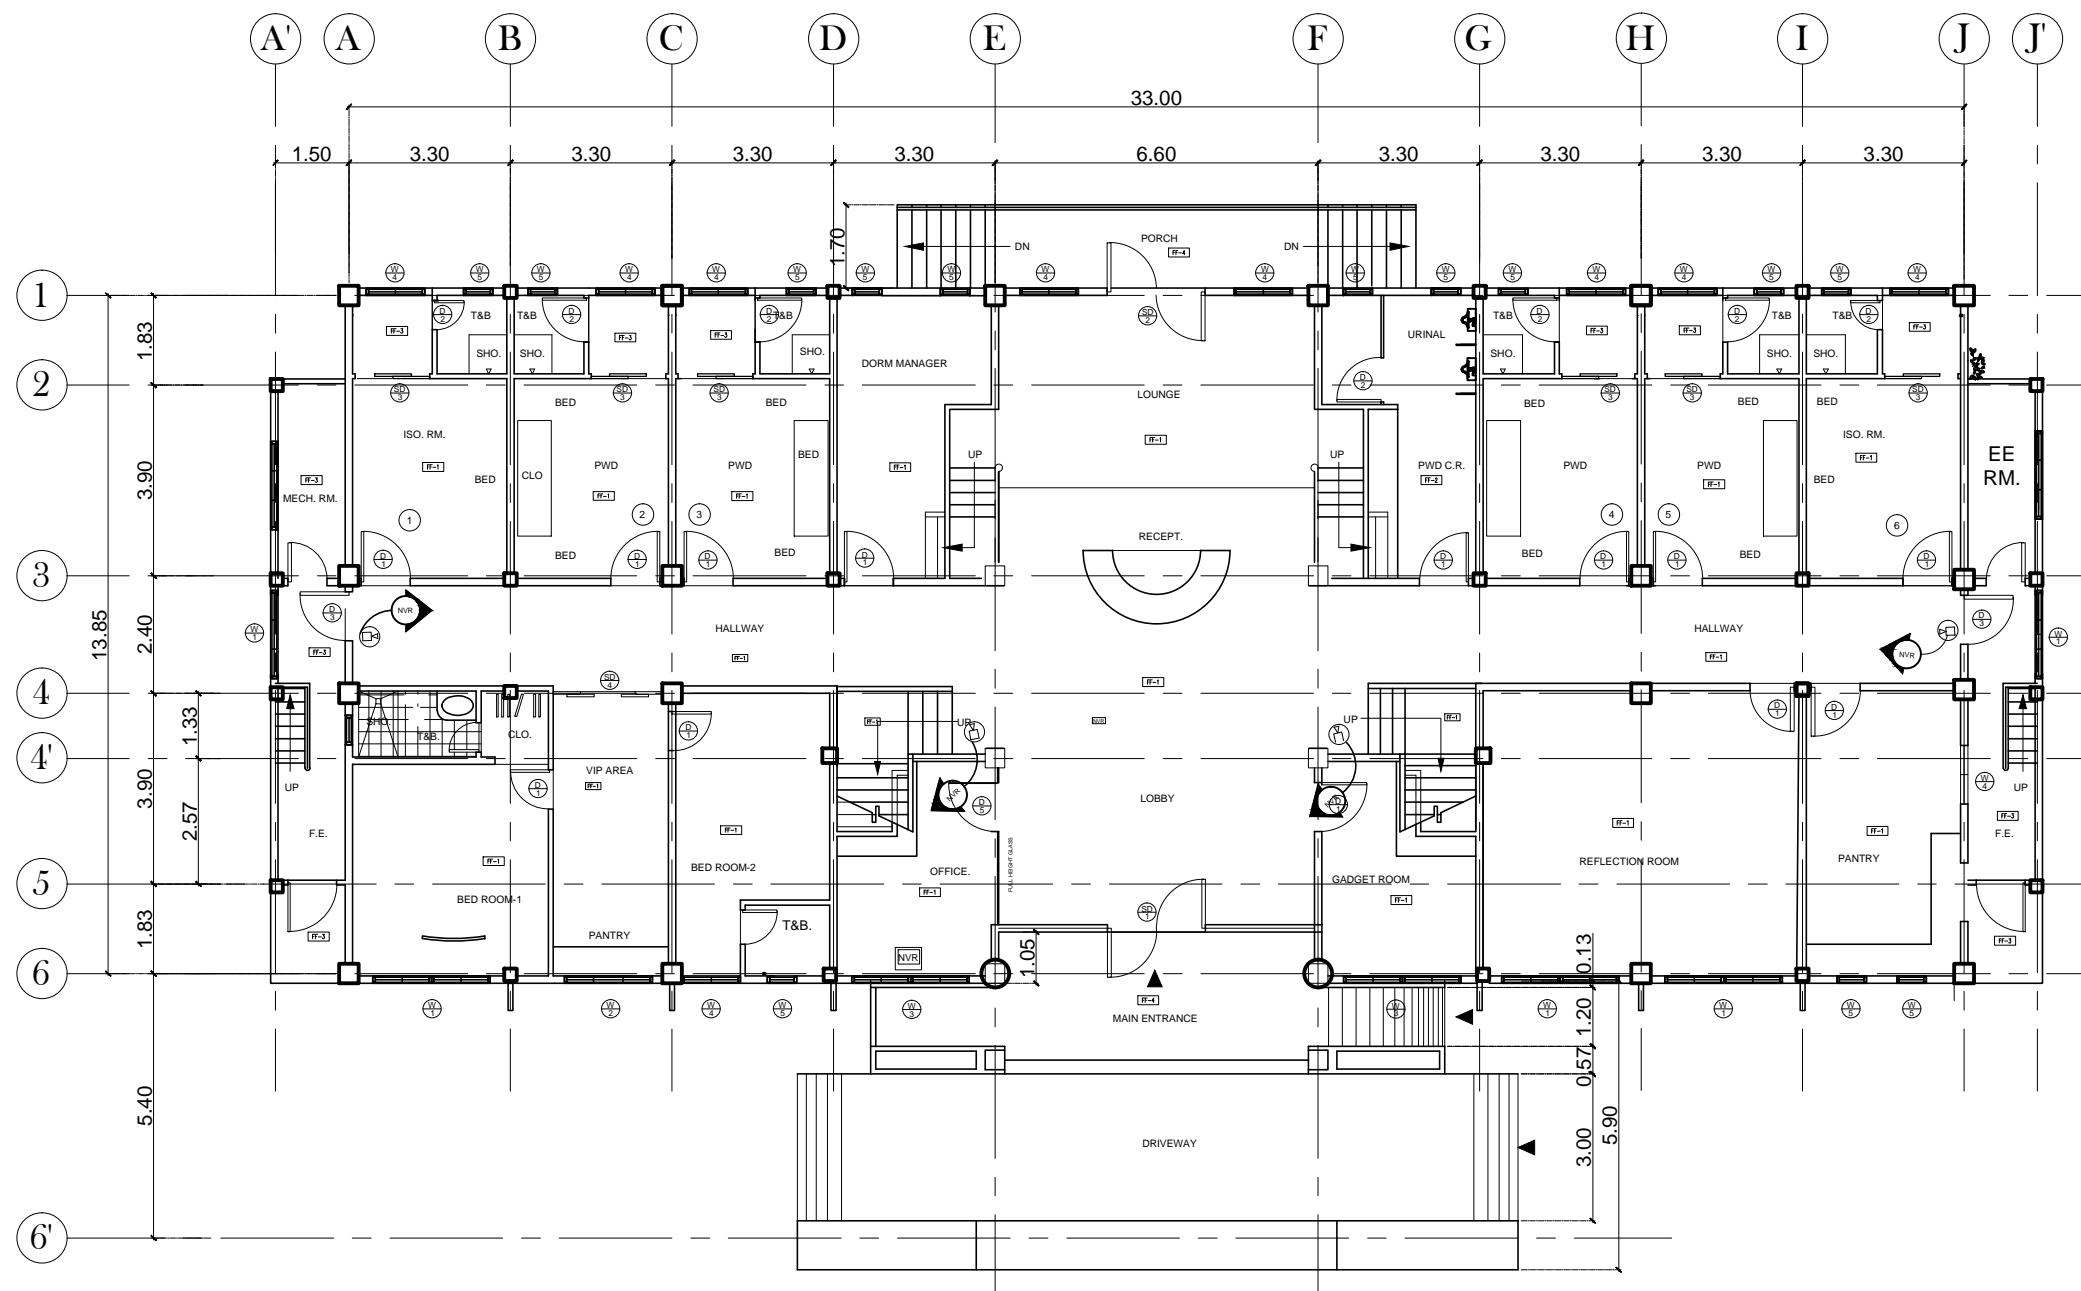


GROUND FLOOR  
**1**  
**CCTV LAYOUT**  
 EC 6 SCALE 1:150MTS

OWNER:	Project Title:	Prepared by:	Recommending approval by:	Approved by:	Sheet Content:	Sheet No.
Republic of the Philippines DEPARTMENT OF SCIENCE AND TECHNOLOGY Philippine Science High School MIMAROPA Region Campus Brgy. Rizal, Odiongan, Romblon 5505	<b>CONSTRUCTION OF DORMITORY BUILDING I</b>	<b>PLANNING TEAM</b>	<u>Meriam F. Fallar</u> FAD Chief	<u>Edward C. Albaracin</u> Campus Director	As Shown	EC
	Location: Brgy. Rizal, Odiongan Romblon 5505	Date Prepared:	Date:	Date:	Date:	6

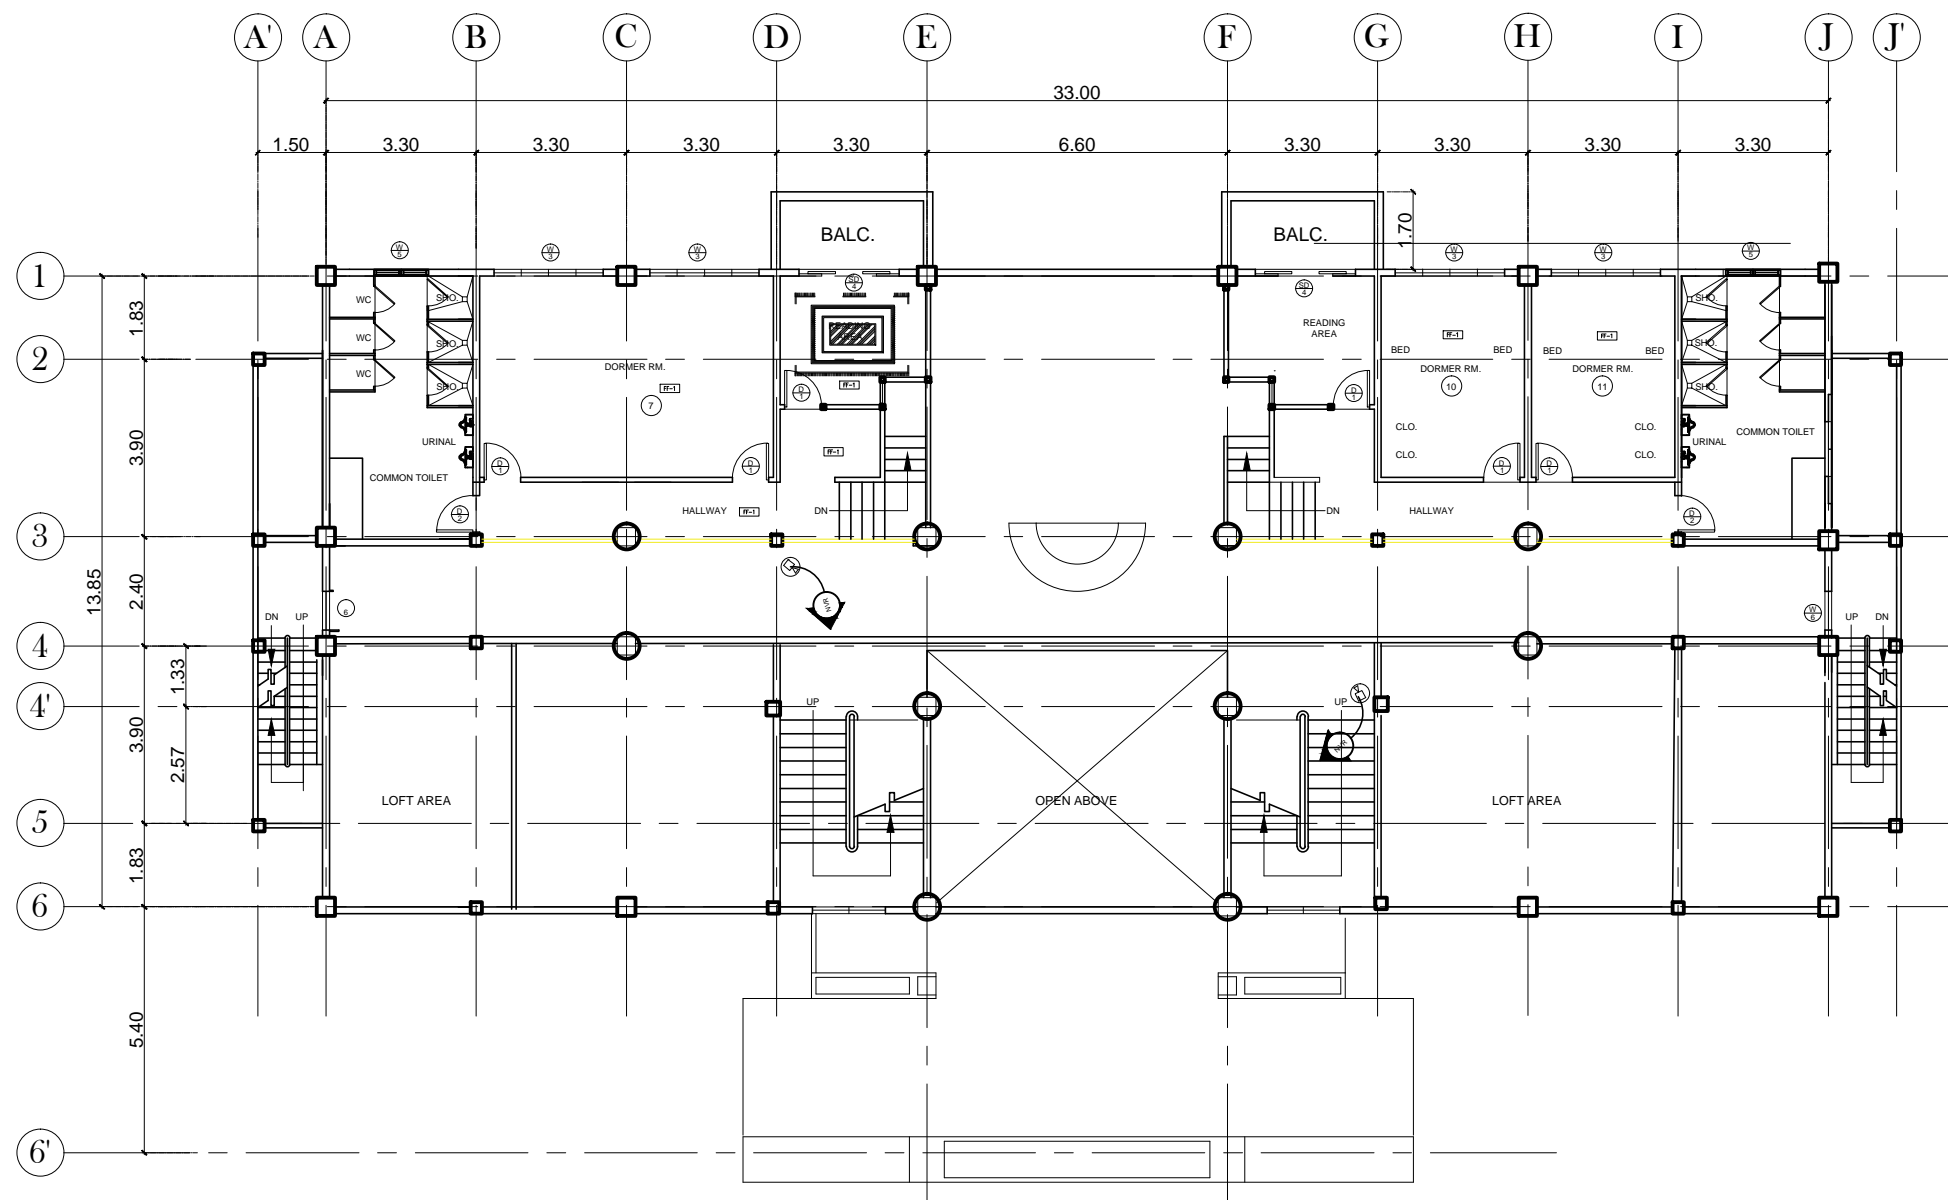

MEZZANINE FLOOR  
1 **CCTV LAYOUT**  
 EC 7 SCALE 1:150MTS


OWNER:	Project Title:	Prepared by:	Recommending approval by:	Approved by:	Sheet Content:	Sheet No.
 Republic of the Philippines DEPARTMENT OF SCIENCE AND TECHNOLOGY Philippine Science High School MIMAROPA Region Campus Brgy. Rizal, Odiongan, Romblon 5505	<b>CONSTRUCTION OF DORMITORY BUILDING I</b>	<b>PLANNING TEAM</b>	<u>Meriam F. Fallar</u> FAD Chief	<u>Edward C. Albaracin</u> Campus Director	As Shown	EC
	Location: Brgy. Rizal, Odiongan Romblon 5505	Date Prepared:	Date:	Date:	Date:	7

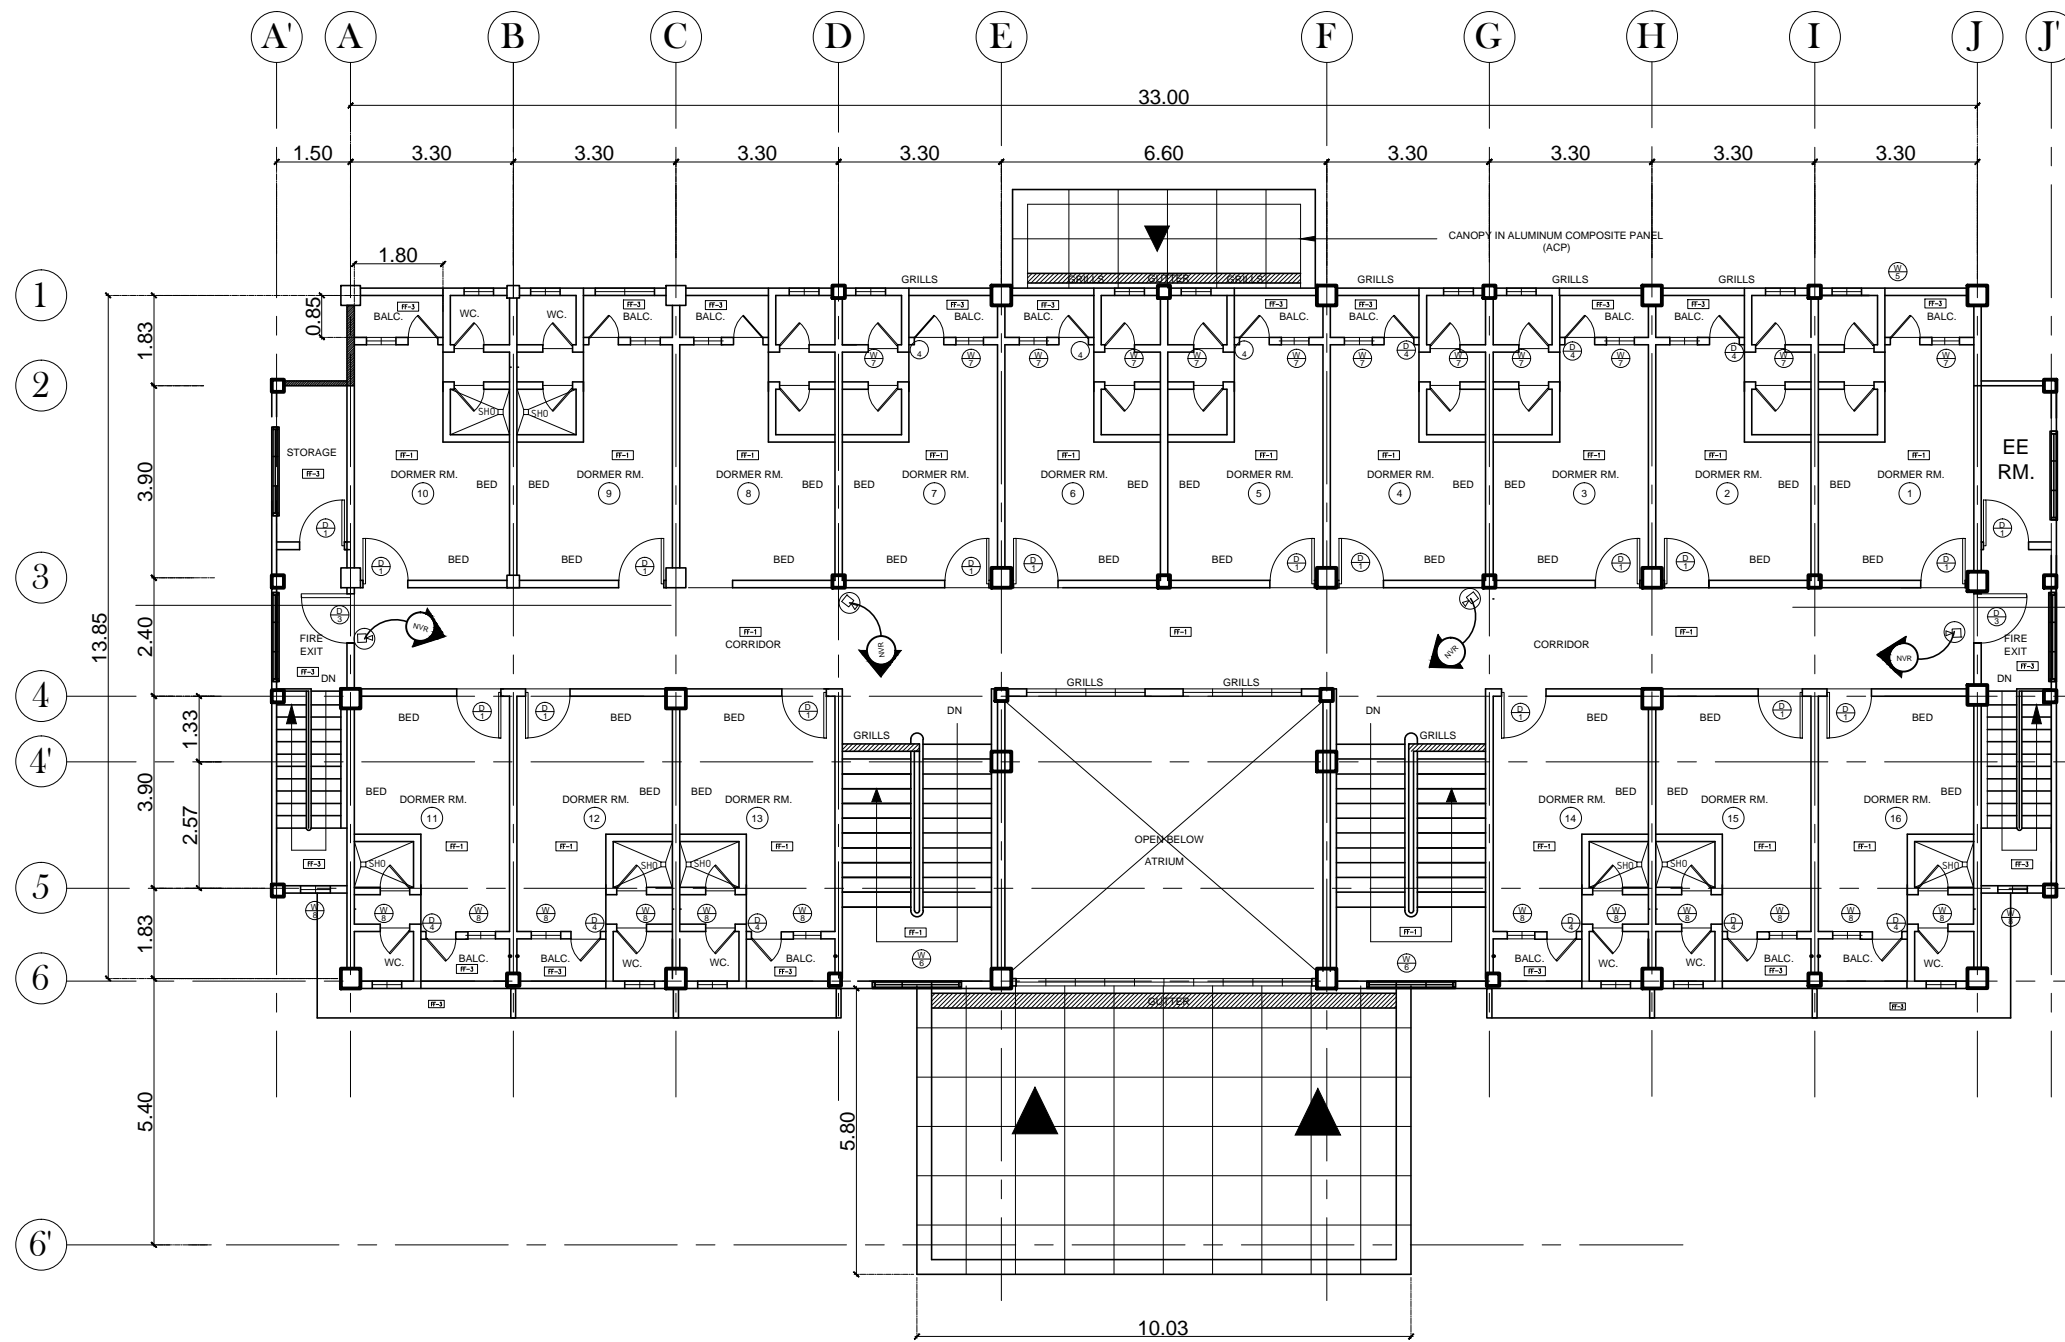

1  
**SECOND FLOOR**  
**CCTV LAYOUT**  
 EC 8 SCALE 1:150MTS


OWNER:	Project Title:	Prepared by:	Recommending approval by:	Approved by:	Sheet Content:	Sheet No.
Republic of the Philippines DEPARTMENT OF SCIENCE AND TECHNOLOGY Philippine Science High School MIMAROPA Region Campus Brgy. Rizal, Odiongan, Romblon 5505	<b>CONSTRUCTION OF DORMITORY BUILDING I</b>	<u>PLANNING TEAM</u>	<u>Meriam F. Fallar</u> FAD Chief	<u>Edward C. Albaracin</u> Campus Director	As Shown	EC
	Location: Brgy. Rizal, Odiongan Romblon 5505	Date Prepared:	Date:	Date:	8	10



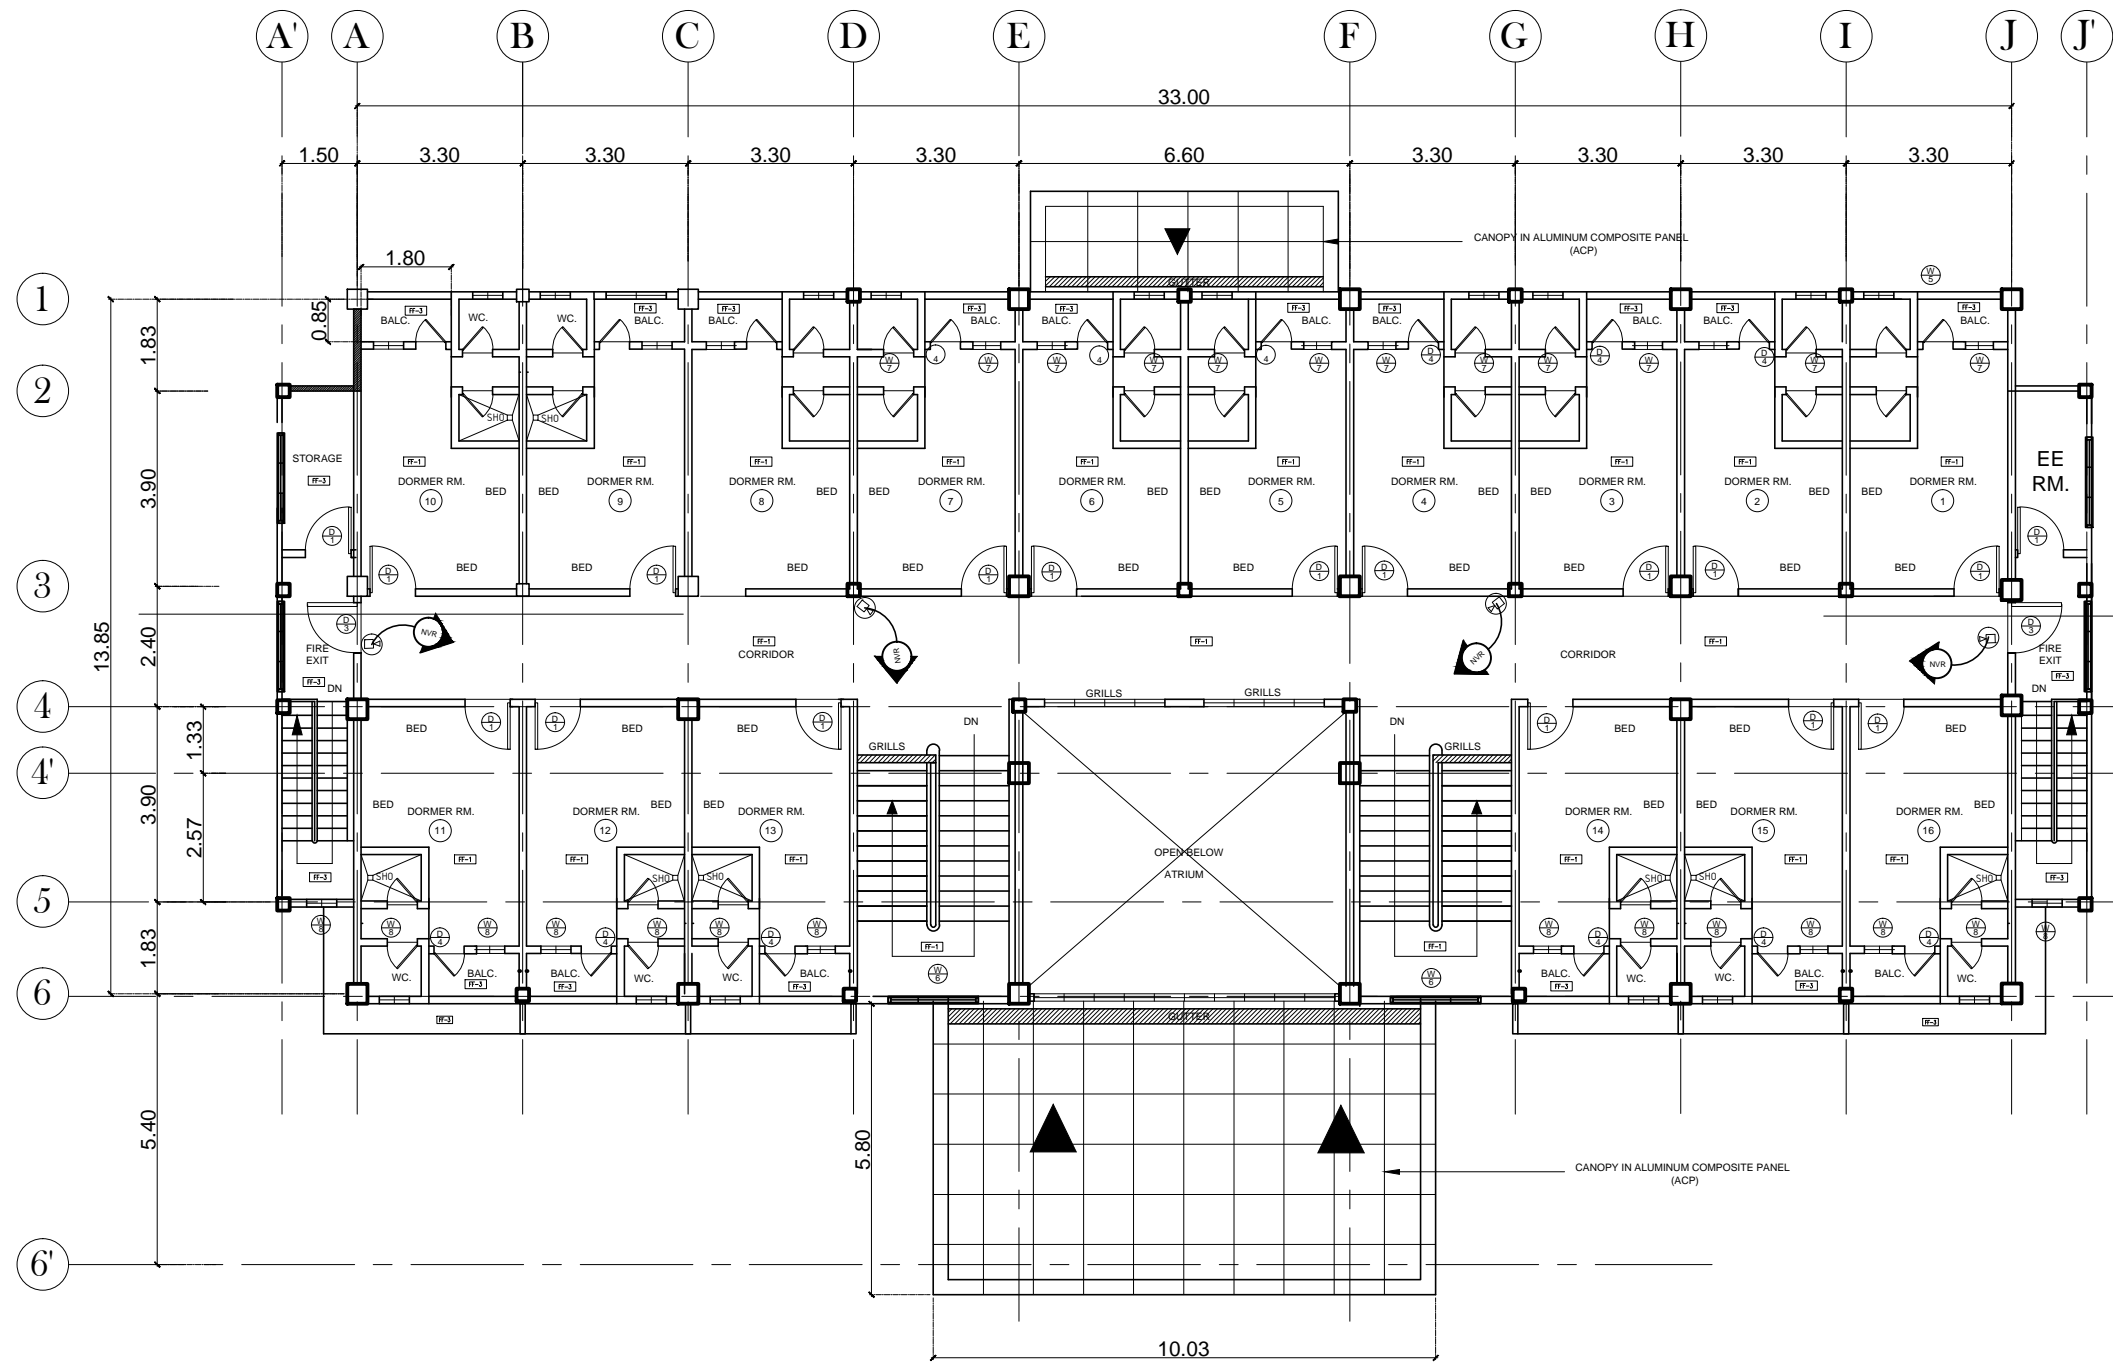

1  
**THIRD FLOOR**  
**CCTV LAYOUT**  
 EC 9 SCALE 1:150MTS

OWNER:	Project Title:	Prepared by:	Recommending approval by:	Approved by:	Sheet Content:	Sheet No.
Republic of the Philippines DEPARTMENT OF SCIENCE AND TECHNOLOGY Philippine Science High School MIMAROPA Region Campus Brgy. Rizal, Odiongan, Romblon 5505	<b>CONSTRUCTION OF DORMITORY BUILDING I</b>	<b>PLANNING TEAM</b>	<b>Meriam F. Fallar</b> FAD Chief	<b>Edward C. Albaracin</b> Campus Director	As Shown	EC
	Location: Brgy. Rizal, Odiongan Romblon 5505	Date Prepared:	Date:	Date:		9

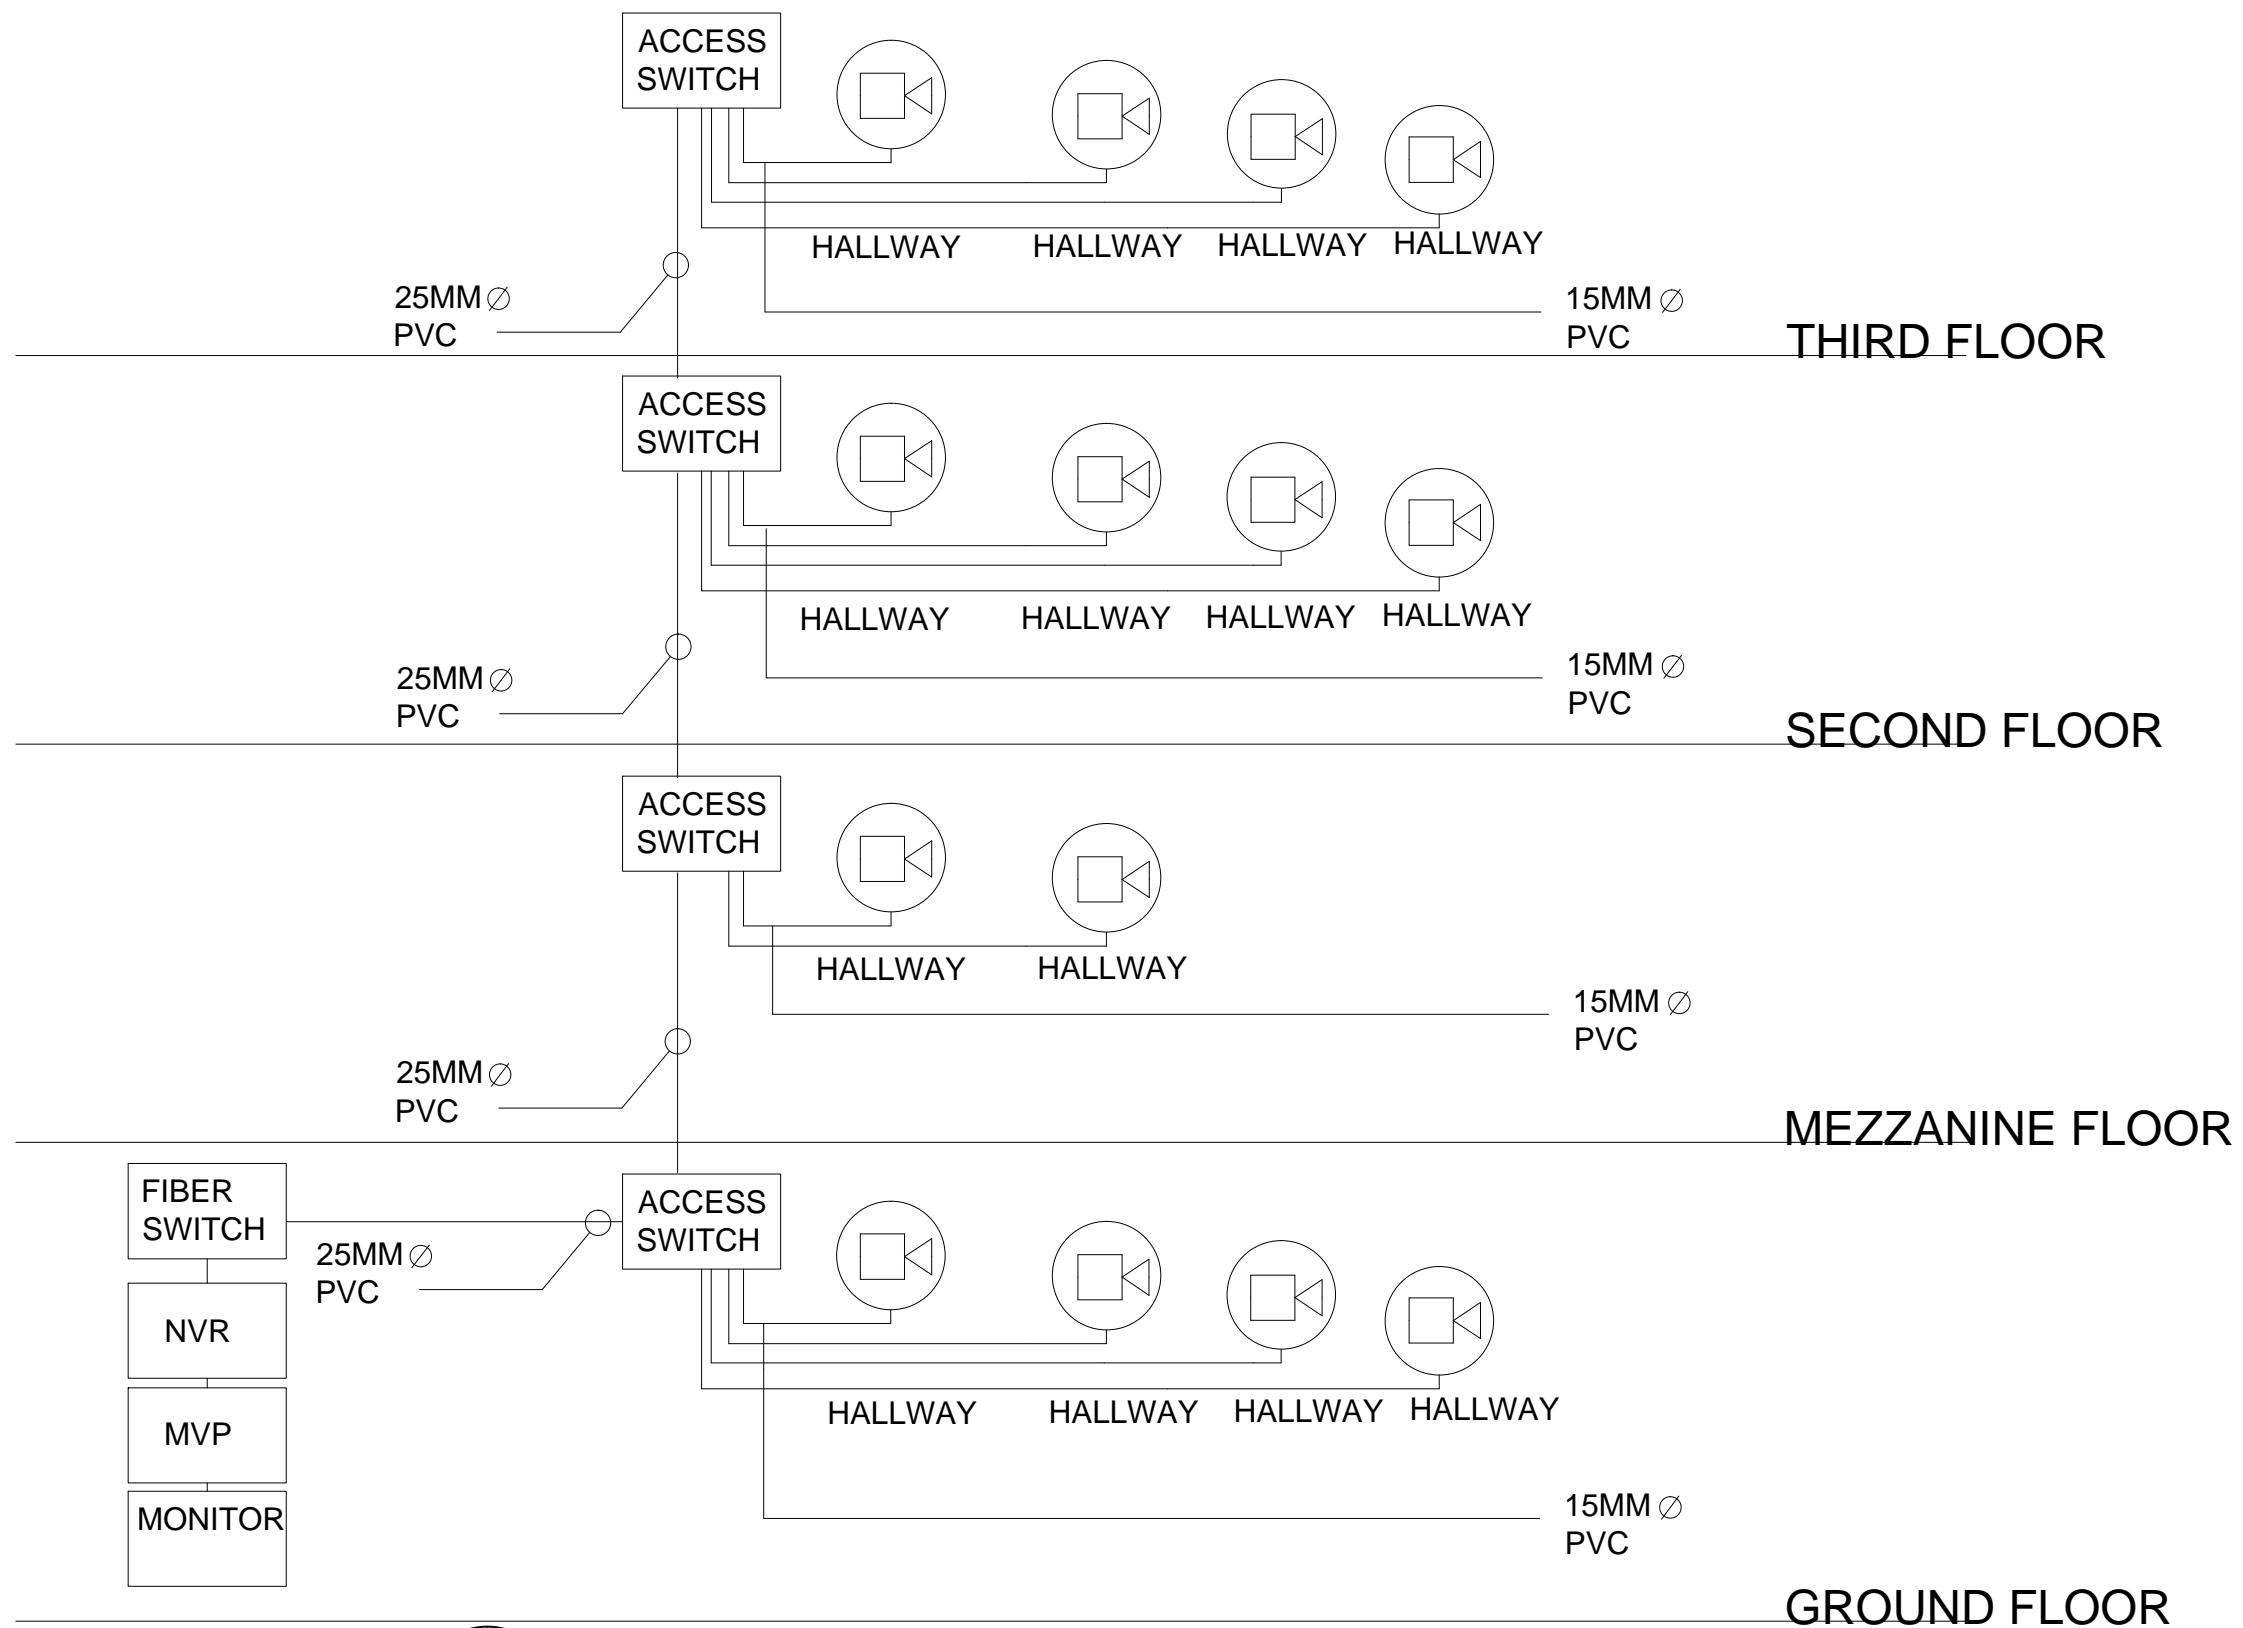

1
**CCTV LAYOUT**  
 EC 10 SCALE 1:150MTS

OWNER:	Project Title:	Prepared by:	Recommending approval by:	Approved by:	Sheet Content:	Sheet No.
<div style="border: 1px solid black; padding: 2px; font-size: 8px;">           ..\Pisay logo.jpg            Republic of the Philippines            DEPARTMENT OF SCIENCE AND TECHNOLOGY            Philippine Science High School            MIMAROPA Region Campus            Brgy. Rizal, Odiongan, Romblon 5505         </div>	<b>CONSTRUCTION OF DORMITORY BUILDING I</b>	<u>PLANNING TEAM</u>	<u>Meriam F. Fallar</u> FAD Chief	<u>Edward C. Albaracin</u> Campus Director	As Shown	EC
	Location: Brgy. Rizal, Odiongan Romblon 5505	Date Prepared:	Date:	Date:		10   10