



REPUBLIC OF THE PHILIPPINES
 DEPARTMENT OF SCIENCE AND TECHNOLOGY
 FILIPINE SCIENCE HIGH SCHOOL
 MANILA REGION CAMPUS
 NATIONAL SCIENCE CENTER, COMPOUND MANILA


PROJECT TITLE / LOCATION:
PROPOSED DORMITORY BUILDING - 2
 NATIONAL SCIENCE CENTER, COMPOUND MANILA

DRAWN BY:
ARCH. JOLITO S. TAN
 PROJECT ARCHITECT

APPROVED BY:
EDWARD C. ALVARADO
 CHIEF ENGINEER

SHEET CONTENT

SHEET NO.
AR - 03

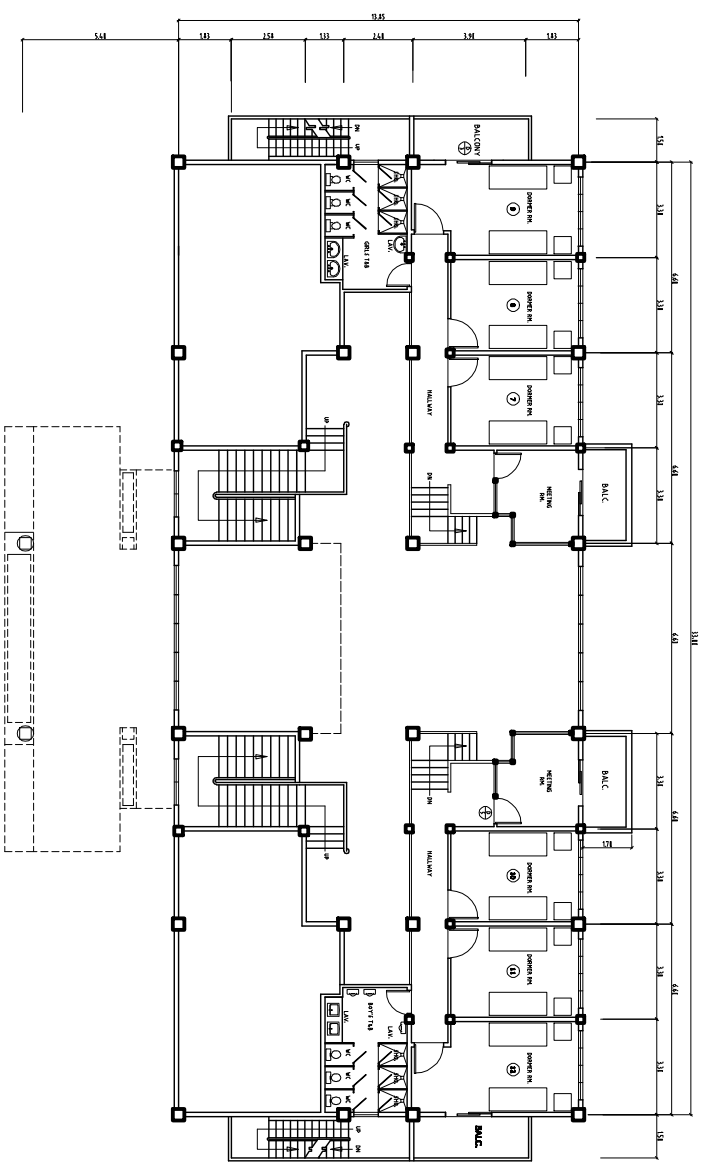

MEZZANINE FLOOR PLAN
 SCALE 1:100
 N.T.S.