



PERSPECTIVE PLAN

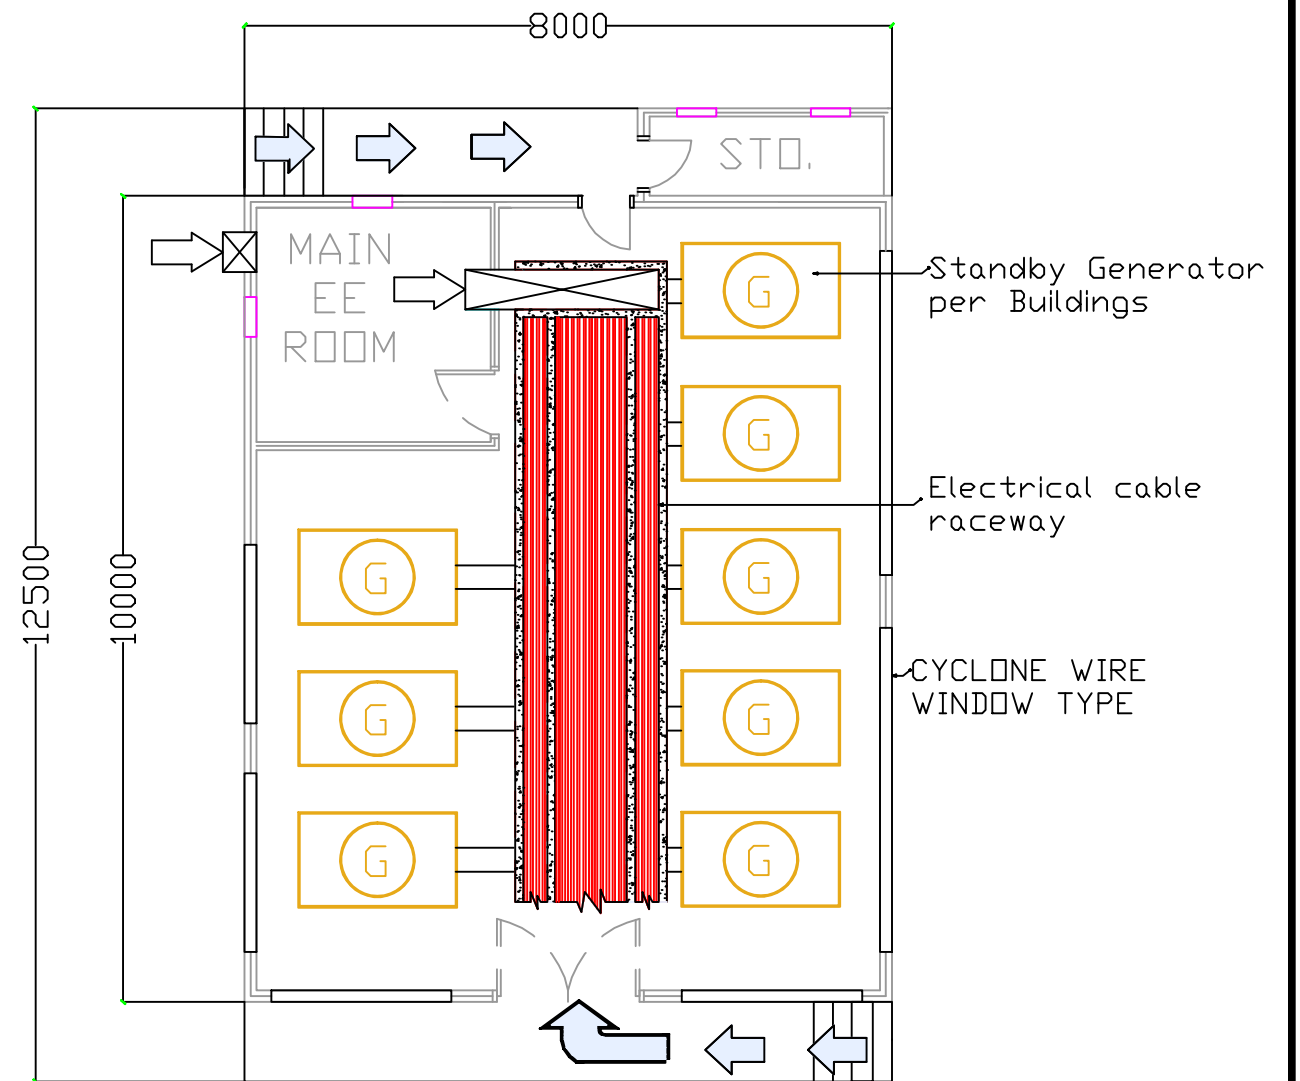

FLOOR PLAN

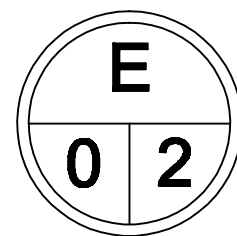

MAIN POWERHOUSE CONCEPT  
 PERSPECTIVE & FLOOR PLAN  
 SCALE NTS

<b>ARCHITECT:</b> JOLITO G. TAN REGISTERED & LICENSED ARCHITECT		<b>PROJECT TITLE:</b> CONSTRUCTION OF ELECTRICAL DISTRIBUTION SYSTEM (W/ GENSETS AND TRANSFORMERS)		<b>APPROVED:</b> EDWARD C. ALBARACIN CAMPUS DIRECTOR		<b>SHEET CONTENTS</b> MAIN POWERHOUSE PERSPECTIVE & FLOOR PLAN DESIGN CONCEPT		<b>SHEET NO.</b> E 0 2	
PRC NO.: 18228 PTR NO.: 3804228 TIN NO.: 128-716-446	ISSUED ON: 11-09-76 ISSUED ON: 01-05-17 ISSUED AT: QUEZON CITY	LOCATION: MIMAROPA REGION CAMPUS, ODIONGAN, ROMBLON		REPUBLIC OF THE PHILIPPINES DEPARTMENT OF SCIENCE AND TECHNOLOGY PHILIPPINE SCIENCE HIGH SCHOOL MIMAROPA REGION CAMPUS BRGY. RIZAL, ODIONGAN, ROMBLON		THIS DOCUMENT IS AN INSTRUMENT OF PROFESSIONAL SERVICE AND AS SUCH MAY NOT BE REPRODUCED IN WHOLE OR IN PART WITHOUT THE WRITTEN CONSENT OF THE ARCHITECT. -P.A. 545			