

 











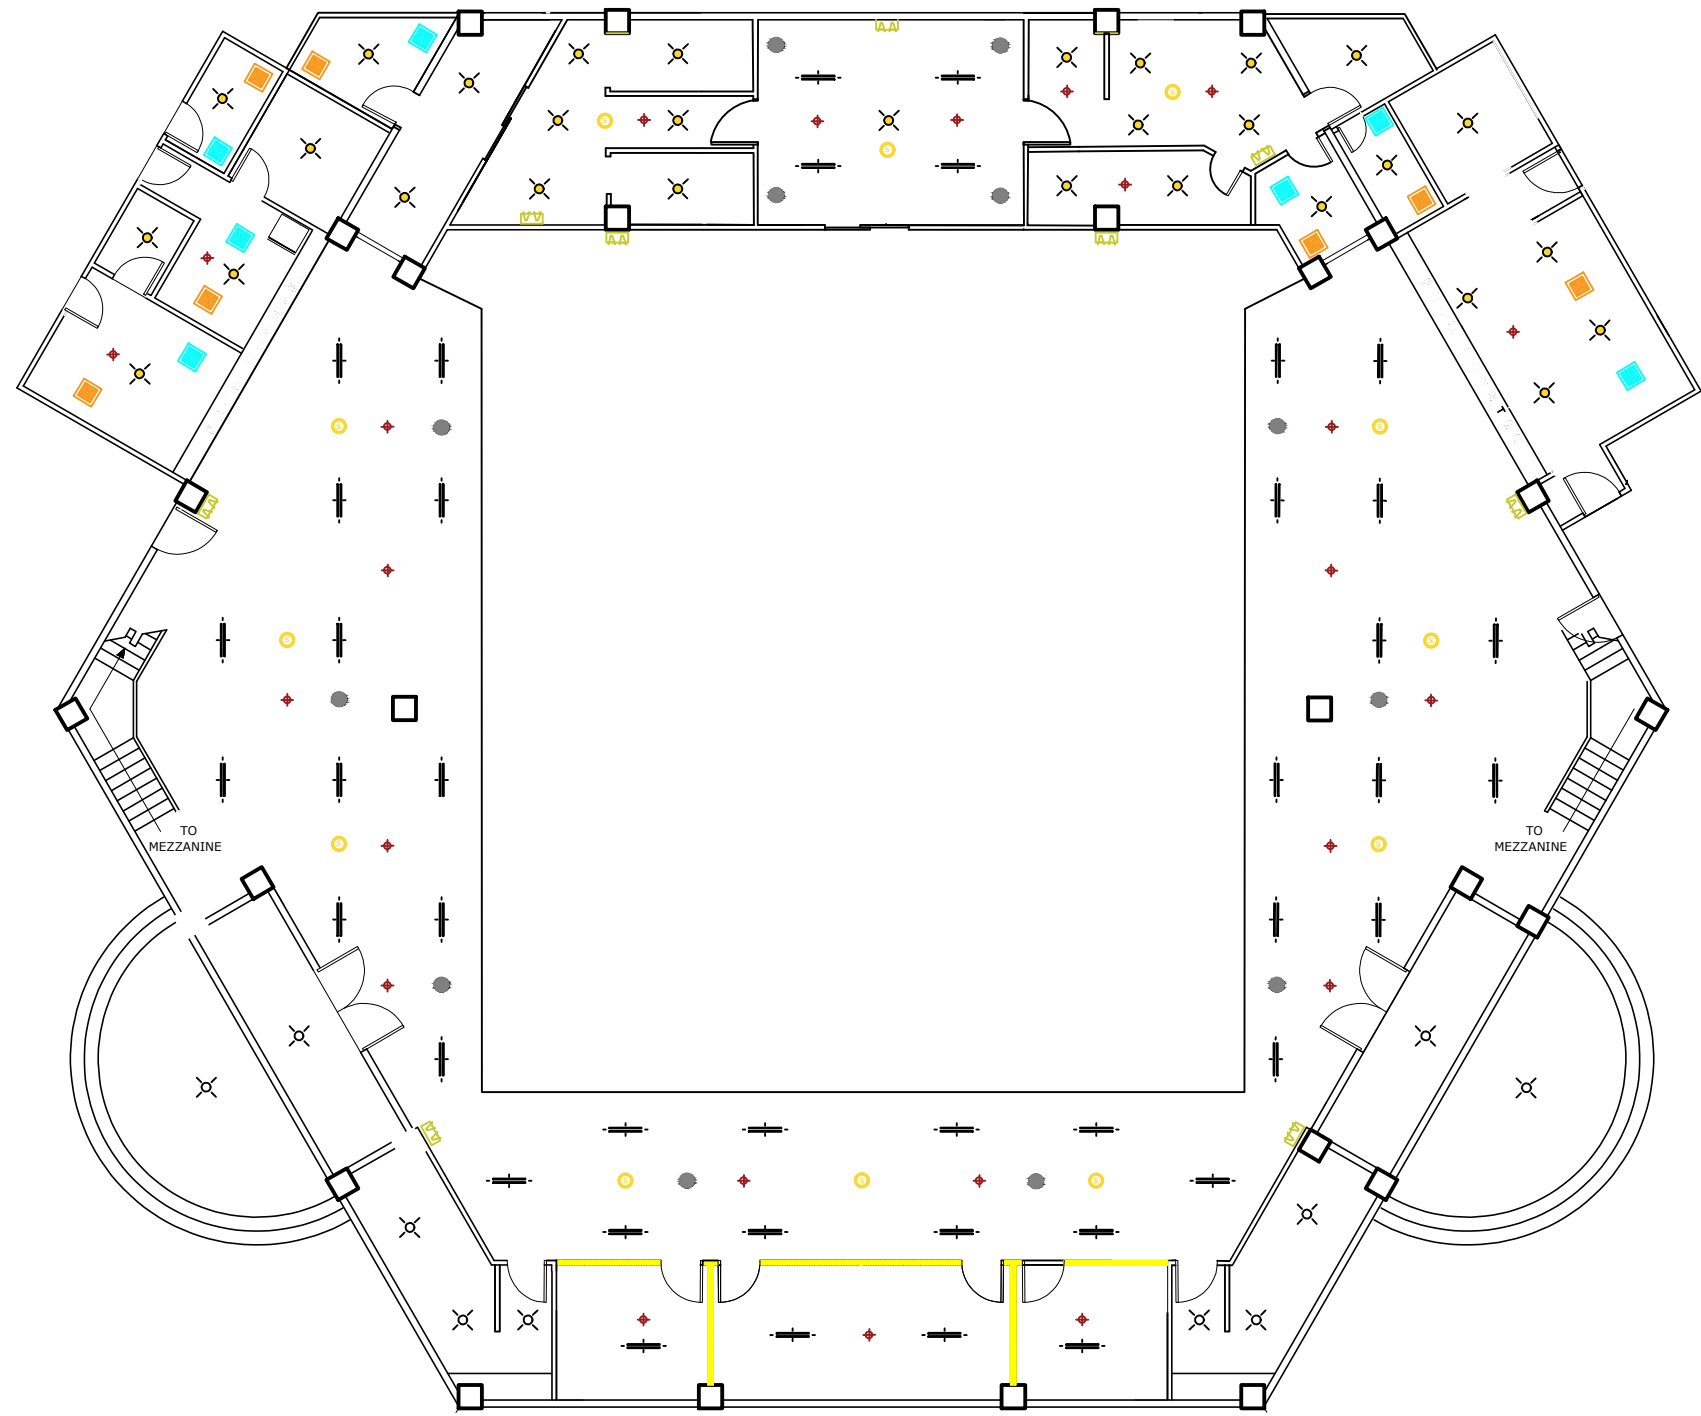


LEGEND & SYMBOLS




-  — EXHAUST AIR GRILLES
-  — FRESH AIR GRILLES
-  — TROFFER LIGHT
CEILING MOUNTED
(Supply and install by the contractor @ Phase 1)
-  — DOUBLE GIMBAL LIGHT
-  — CHANDILIER
-  — LED PINLIGHT
(Supply and install by the contractor @ Phase 1)
-  — SQUARE TYPE RECESSED LED LIGHT
-  — CYLINDRICAL PORCELAIN LIGHT
-  — EMERGENCY LIGHT
-  — FIRE SPRINKLER
-  — SMOKE DETECTOR
-  — CEILING MOUNTED SPEAKER
-  — FLOOR OUTLET
-  — DRYWALL PARTITION



Note:

1. This drawing is for contractor reference.
2. Specification of fixtures shall be approved by the owner, contractor shall submit their specification for during design phase for approval.


 Ground Floor
REFLECTED CEILING PLAN
 Scale 1:1

OWNER:	Project Title:	Prepared by:	Recommending approval by:	Approved by:	Sheet Content:	Sheet No.
 Republic of the Philippines DEPARTMENT OF SCIENCE AND TECHNOLOGY Philippine Science High School MIMAROPA Region Campus Brgy. Rizal, Odiongan, Romblon 5505	Design and Build Scheme Infrastructure Project: Completion of School Canteen and Student Activity Center	<u>Engr. Joseph G. Bantang</u> Resident Engineer, DBC	 <u>Meriam F. Fallar</u> BAC - Chairman	 <u>Edward C. Albaracin</u> Campus Director	As Shown	RCP
	Location: Brgy. Rizal, Odiongan Romblon 5505	Date Prepared: November 19, 2019	Date: November 19, 2019	Date: November 19, 2019		0