


APPENDIX F

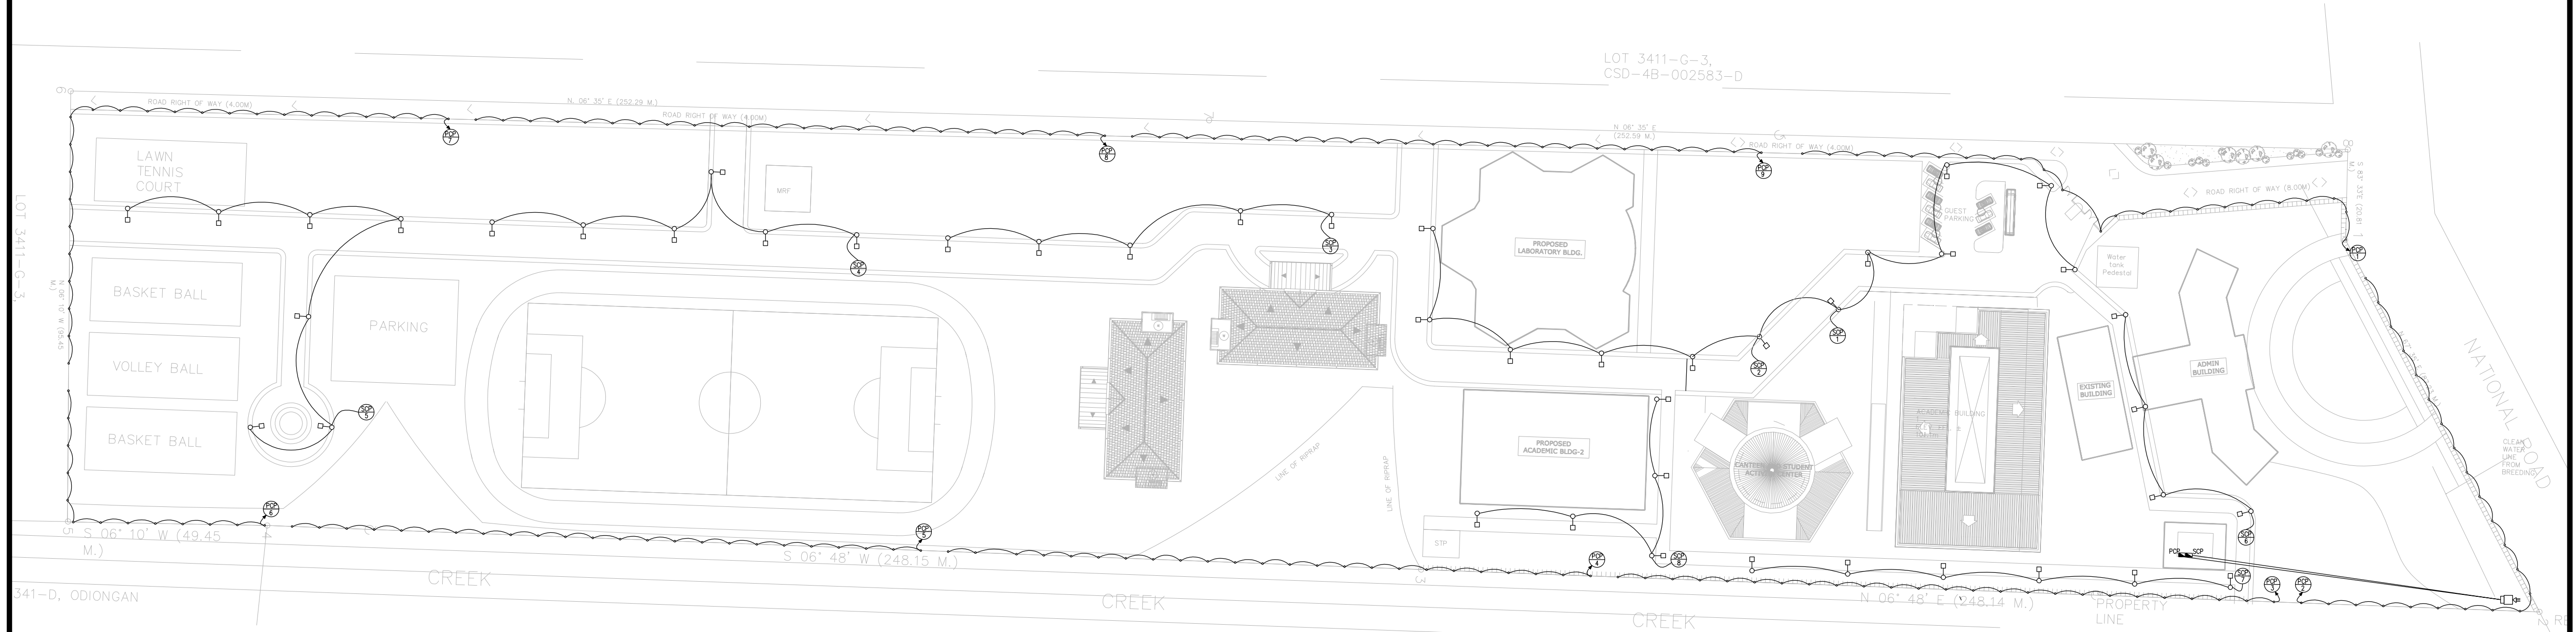

1 PERIMETER & STREET LIGHTING LAYOUT
 E-2 SCALE 1:800m

FOR CONSTRUCTION

MELISA R. RAMIREZ
 AUTHORIZED MANAGER OFFICER DATE

 Legazpi Premium Development Corporation	ENGINEER: ARMANDO S. CALAGUAS PROFESSIONAL ELECTRICAL ENGINEER	PROJECT TITLE: SITE DEVELOPMENT (Development of Campus Master Plan, Construction of Road Network)	 REPUBLIC OF THE PHILIPPINES DEPARTMENT OF SCIENCE AND TECHNOLOGY PHILIPPINE SCIENCE HIGH SCHOOL MIMAROPA REGION CAMPUS BRGY. RIZAL, ODIONGAN, ROMBLON	APPROVED: EDWARD C. ALBARACIN CAMPUS DIRECTOR	DESIGNED BY: ACE 05/19/17 ENCODED BY: ACE 05/19/17 CHECKED BY: ASC 05/19/17 APPROVED BY: ASC 05/19/17	REVISIONS	SHEET CONTENTS AS SHOWN	SHEET NO. E
	PRC NO.: 2375 ISSUED ON: 09-24-90 PTR NO.: 2353110 ISSUED ON: 01-03-17 TIN NO.: 146-594-412 ISSUED AT: QUEZON CITY	LOCATION: MIMAROPA REGION CAMPUS ODIONGAN, ROMBLON			DATE ISSUED: 06/01/17 SCALE: AS SHOWN PROJECT NO.: RBR_SD122916-RBRA-PSM-D-004	THIS DOCUMENT IS AN INSTRUMENT OF PROFESSIONAL SERVICE AND AS SUCH MAY NOT BE REPRODUCED IN WHOLE OR IN PART WITHOUT THE WRITTEN CONSENT OF THE ARCHITECT. -R.A. 545	2	5