
 
 
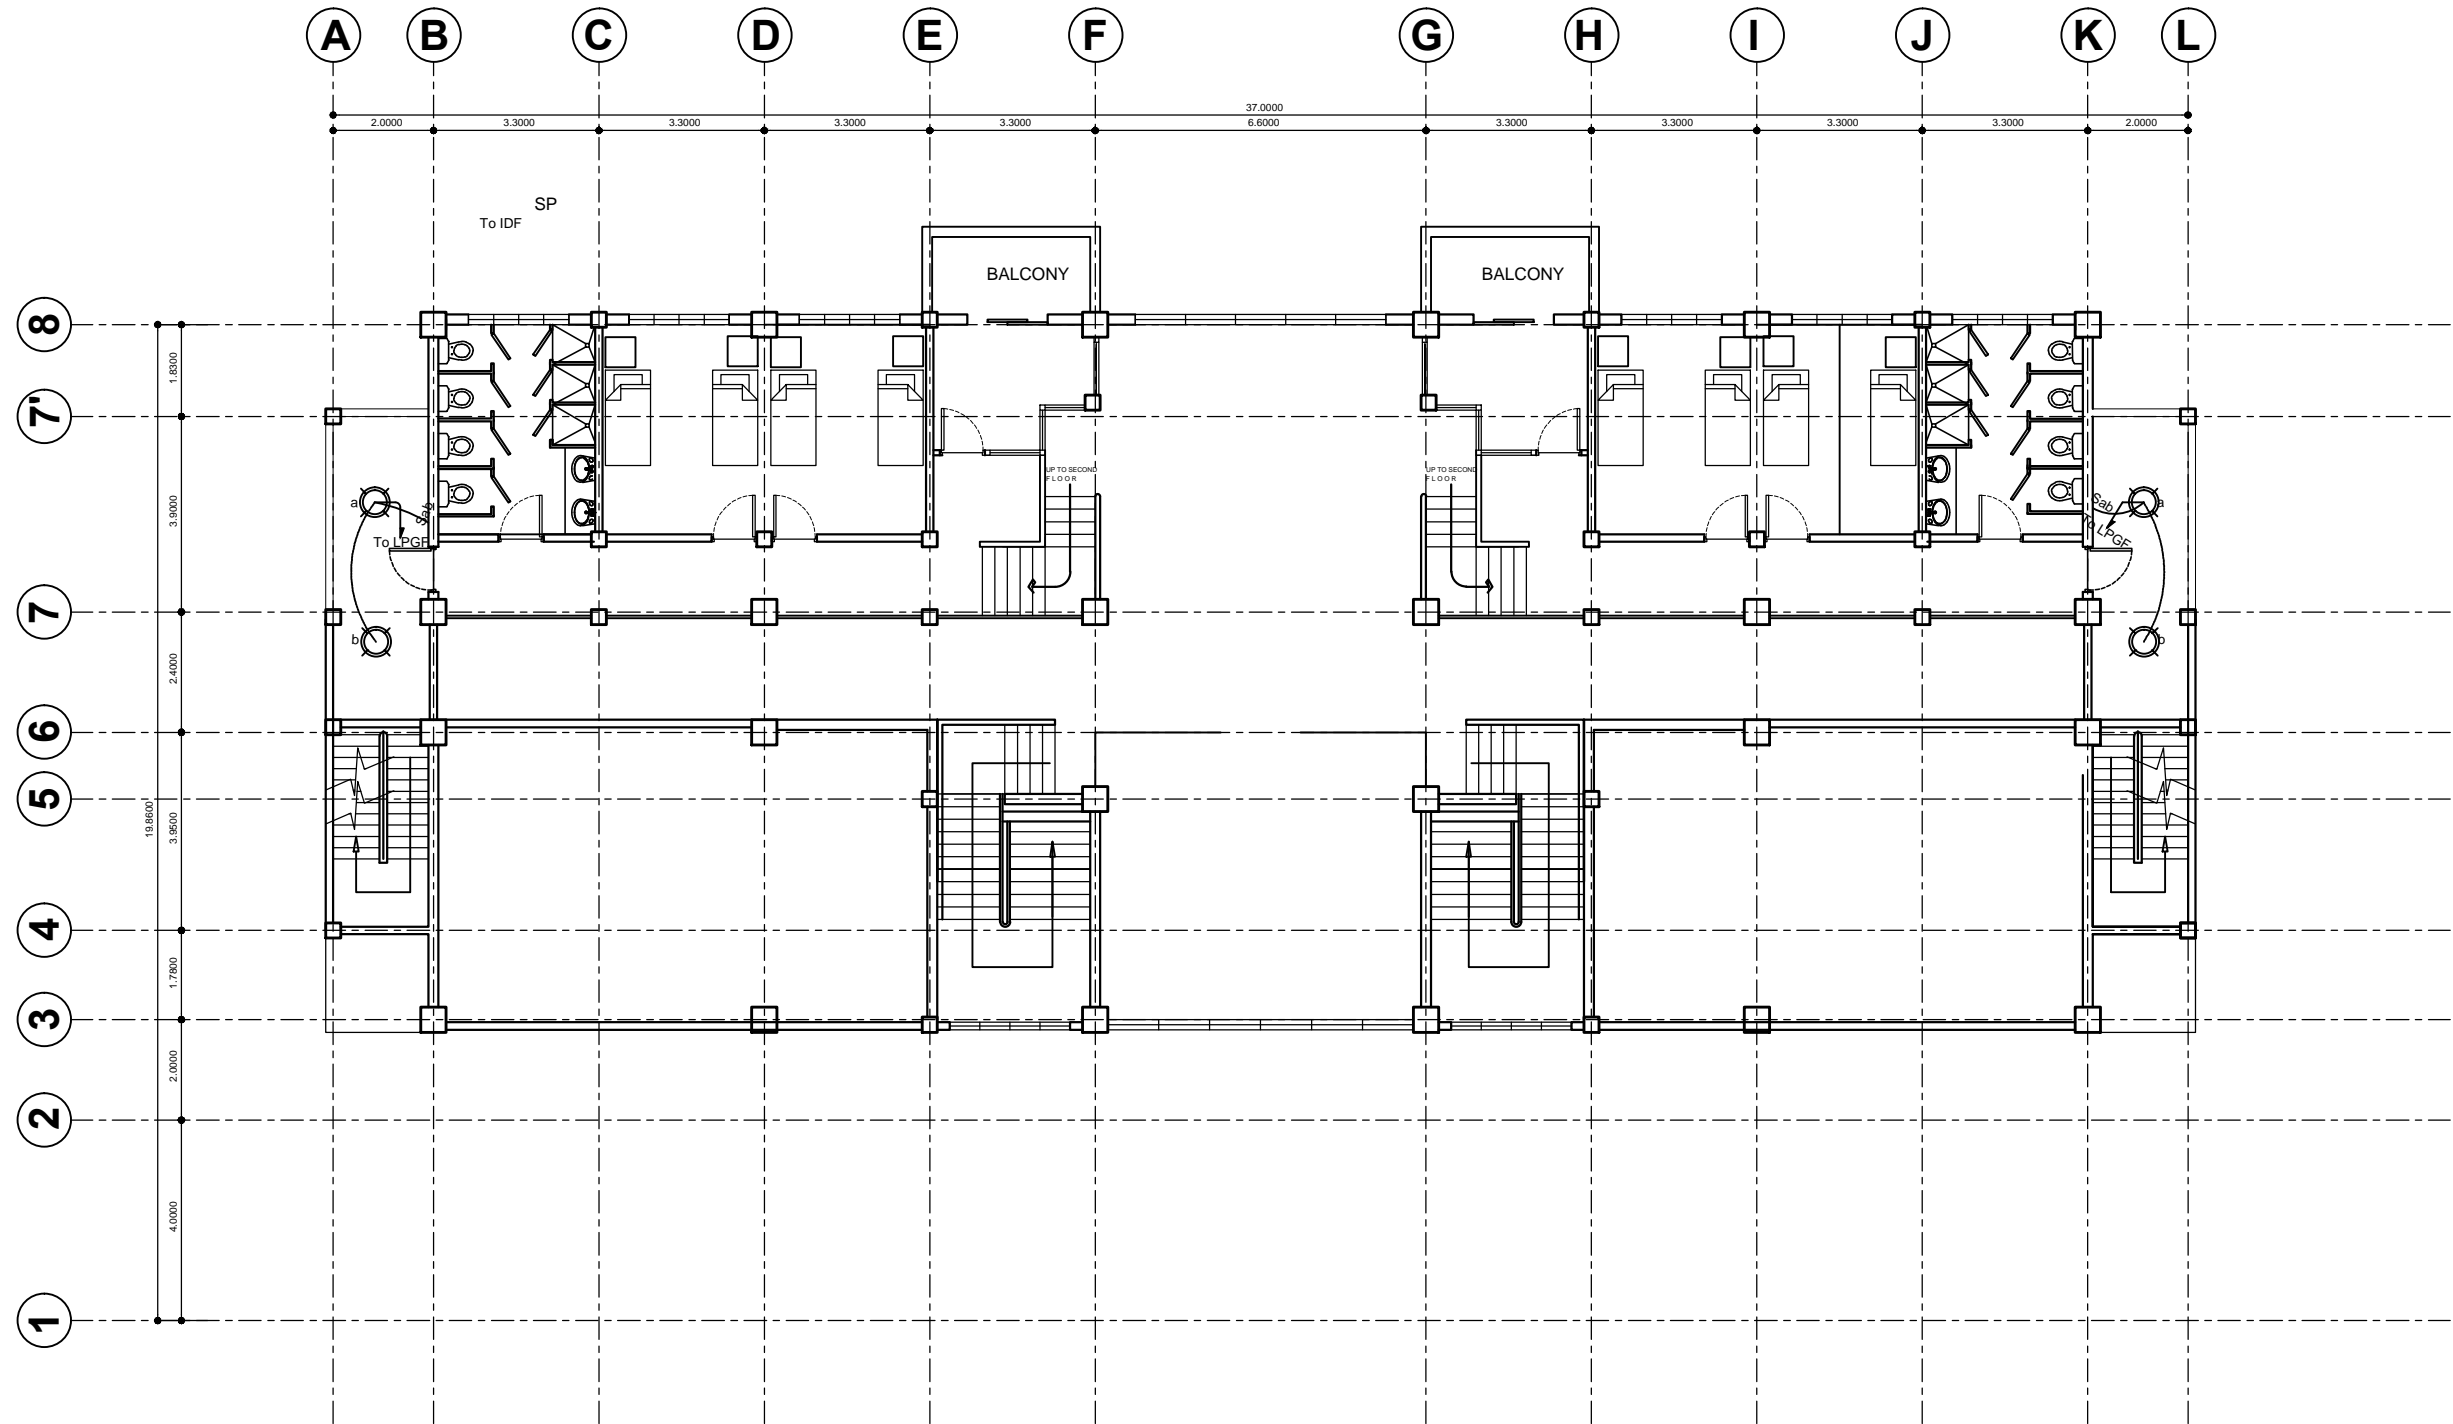


DORMITORY BUILDING II  
**GROUND FLOOR LIGHTING PLAN**

SCALE

1:150MTS




OWNER:	Project Title:	Prepared by:	Recommending approval by:	Approved by:	Sheet Content:	Sheet No.
 Republic of the Philippines DEPARTMENT OF SCIENCE AND TECHNOLOGY Philippine Science High School MIMAROPA Region Campus Brgy. Rizal, Odiongan, Romblon 5505	<b>COMPLETION OF          DORMITORY BUILDING II</b>  Location: Brgy. Rizal, Odiongan Romblon 5505	PLANNING TEAM  Date Prepared:	 Ivy May F. Pamatiga FAD Chief  Date:	 Romeo C. Ongpoy, Jr. Campus Director  Date:	As Shown	EE 2   4




**DORMITORY BUILDING II  
MEZZANINE FLOOR LIGHTING LAY OUT**


SCALE

1:150MTS

OWNER:	Project Title:	Prepared by:	Recommending approval by:	Approved by:	Sheet Content:	Sheet No.
 Republic of the Philippines DEPARTMENT OF SCIENCE AND TECHNOLOGY Philippine Science High School MIMAROPA Region Campus Brgy. Rizal, Odiongan, Romblon 5505	<b>COMPLETION OF DORMITORY BUILDING II</b>	PLANNING TEAM	 Ivy May F. Famatiga FAD Chief	 Romeo C. Ongpoy, Jr. Campus Director	As Shown	EE
	Location: Brgy. Rizal, Odiongan Romblon 5505	Date Prepared:	Date:	Date:		<table border="1"> <tr> <td align="center">3</td> <td align="center">4</td> </tr> </table>
3	4					

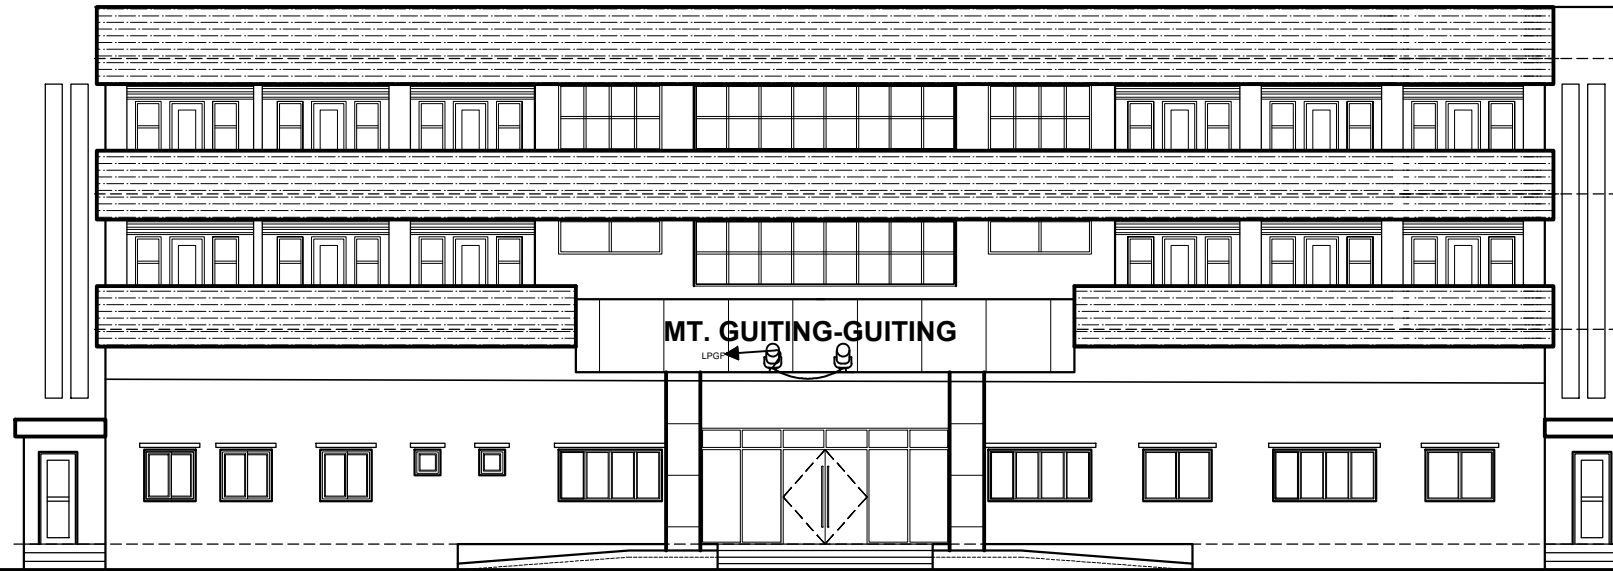


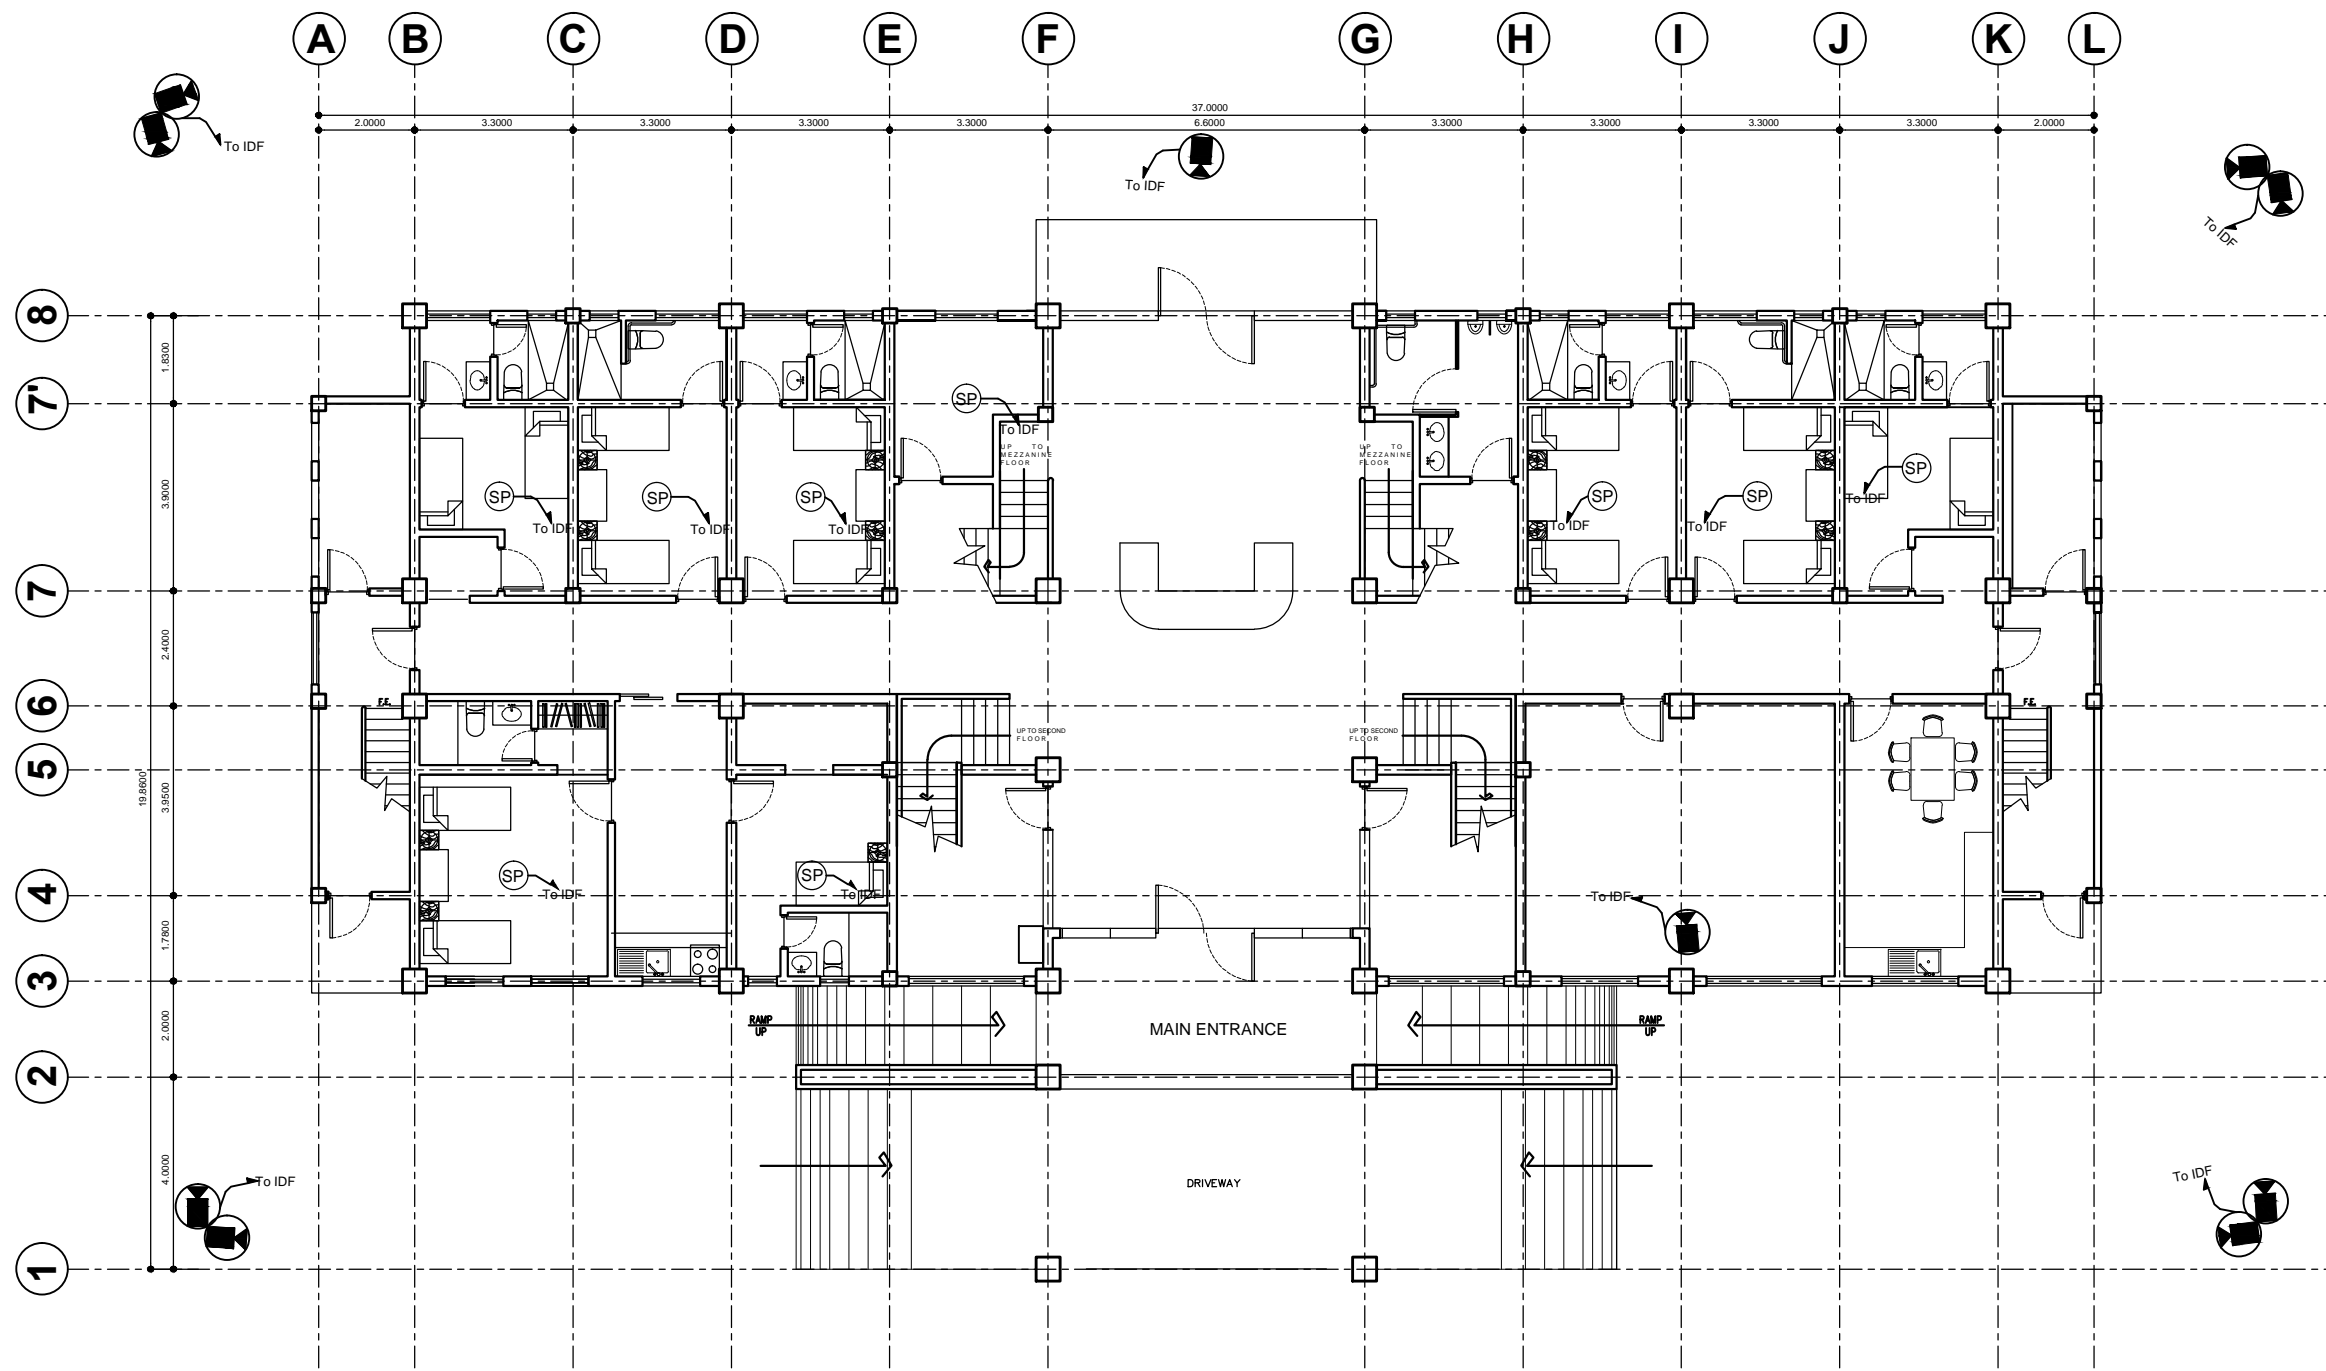
**FRONT ELEVATION**  
SCALE 1:175MTS

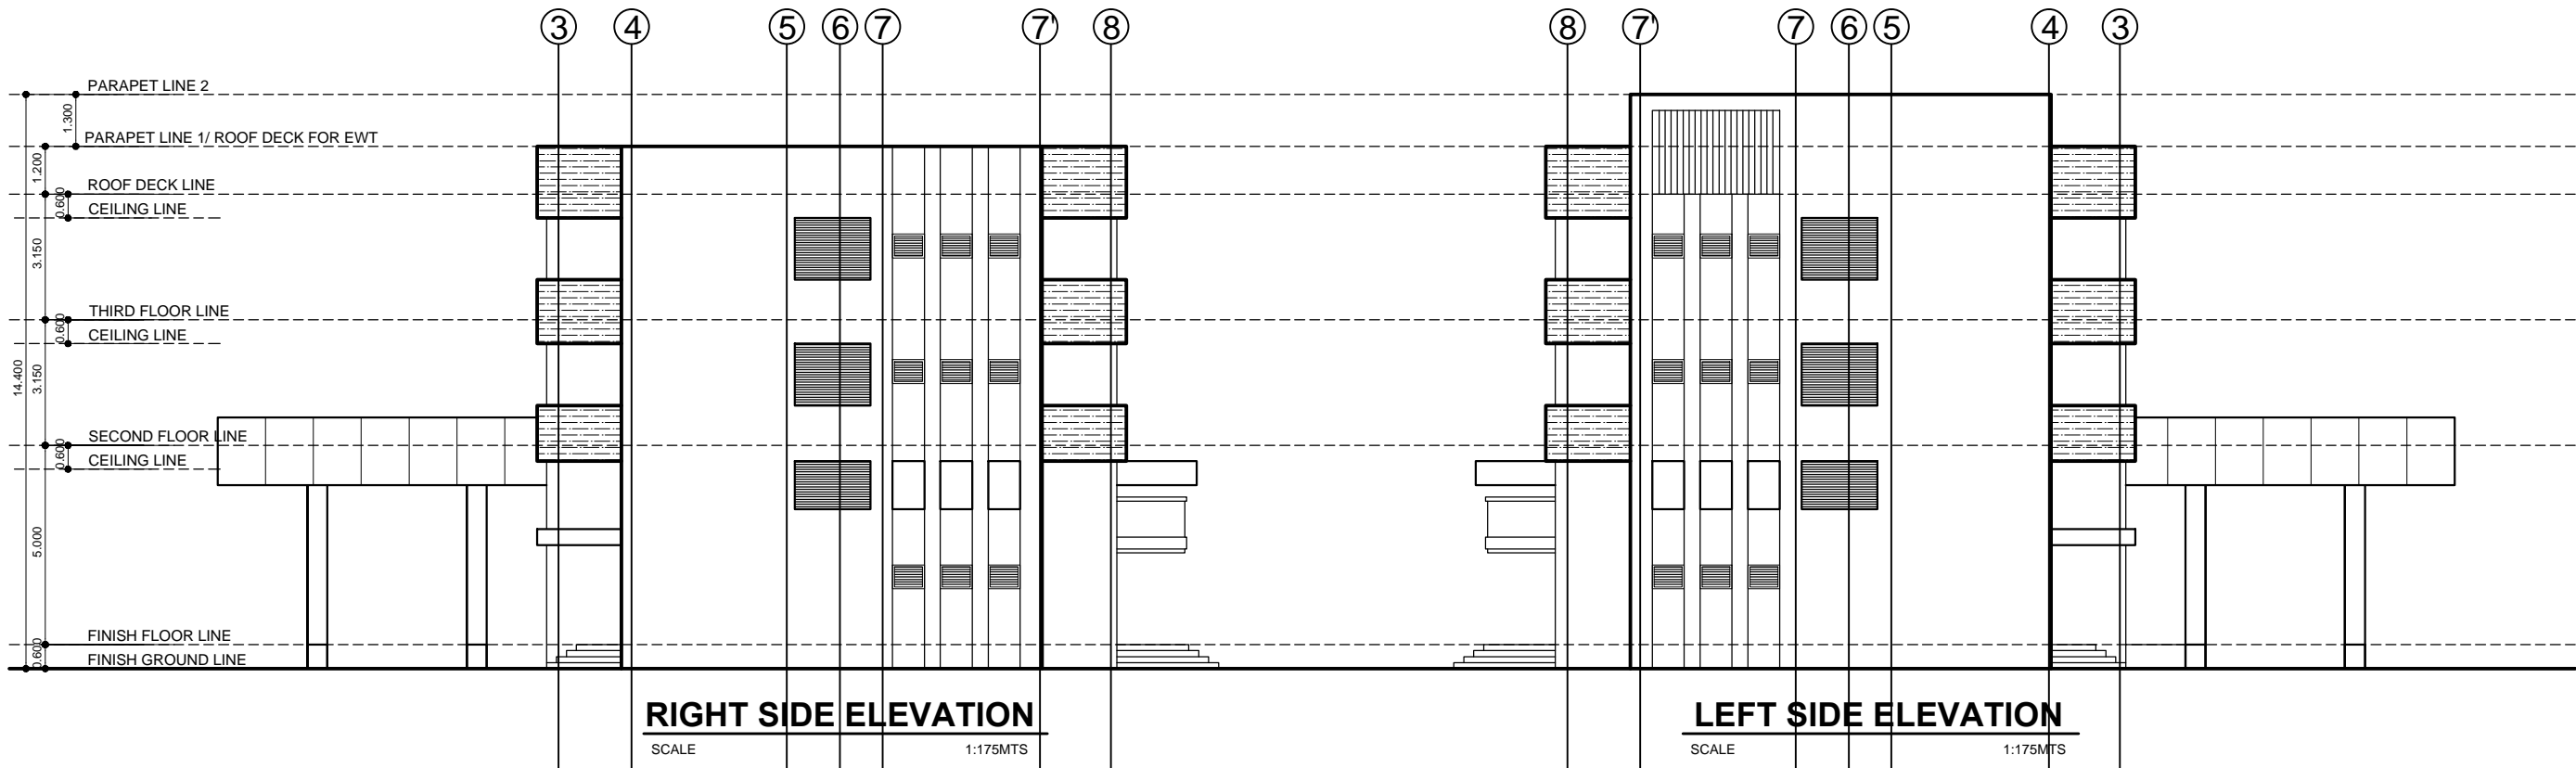

**RIGHT SIDE ELEVATION**  
SCALE 1:175MTS


**LEFT SIDE ELEVATION**  
SCALE 1:175MTS


<b>OWNER:</b>  Republic of the Philippines DEPARTMENT OF SCIENCE AND TECHNOLOGY Philippine Science High School MIMAROPA Region Campus Brgy. Rizal, Odiongan, Romblon 5505	<b>Project Title:</b> <p style="text-align: center;"><b>COMPLETION OF DORMITORY BUILDING II</b></p> Location: Brgy. Rizal, Odiongan Romblon 5505	<b>Prepared by:</b> <p style="text-align: center;"><i>[Signature]</i> <b>PLANNING TEAM</b></p> Date Prepared:	<b>Recommending approval by:</b> <p style="text-align: center;"><i>[Signature]</i> <b>Ivy May F. Pamatiga</b> FAD Chief</p> Date:	<b>Approved by:</b> <p style="text-align: center;"><i>[Signature]</i> <b>Romeo C. Ongpoy, Jr.</b> Campus Director</p> Date:	<b>Sheet Content:</b> <p style="text-align: center;">As Shown</p>	<b>Sheet No.</b> <p style="text-align: center;">EE</p> <table border="1" style="width: 100%; text-align: center;"> <tr> <td>4</td> <td>4</td> </tr> </table>	4	4
4	4							



**DORMITORY BUILDING II  
GROUND FLOOR CCTV LAYOUT**

SCALE \_\_\_\_\_ 1:150MTS


<b>OWNER:</b>	<b>Project Title:</b>	<b>Prepared by:</b>	<b>Recommending approval by:</b>	<b>Approved by:</b>	<b>Sheet Content:</b>	<b>Sheet No.</b>		
 Republic of the Philippines DEPARTMENT OF SCIENCE AND TECHNOLOGY Philippine Science High School MIMAROPA Region Campus Brgy. Rizal, Odiongan, Romblon 5505	<b>COMPLETION OF DORMITORY BUILDING II</b>  Location: Brgy. Rizal, Odiongan Romblon 5505	PLANNING TEAM  Date Prepared:	Ivy May F. Farnatiga FAD Chief  Date:	Romeo C. Ongboy, Jr. Campus Director  Date:	As Shown	EC <table border="1" style="width: 100%;"> <tr> <td style="width: 50%;">1</td> <td style="width: 50%;">3</td> </tr> </table>	1	3
1	3							

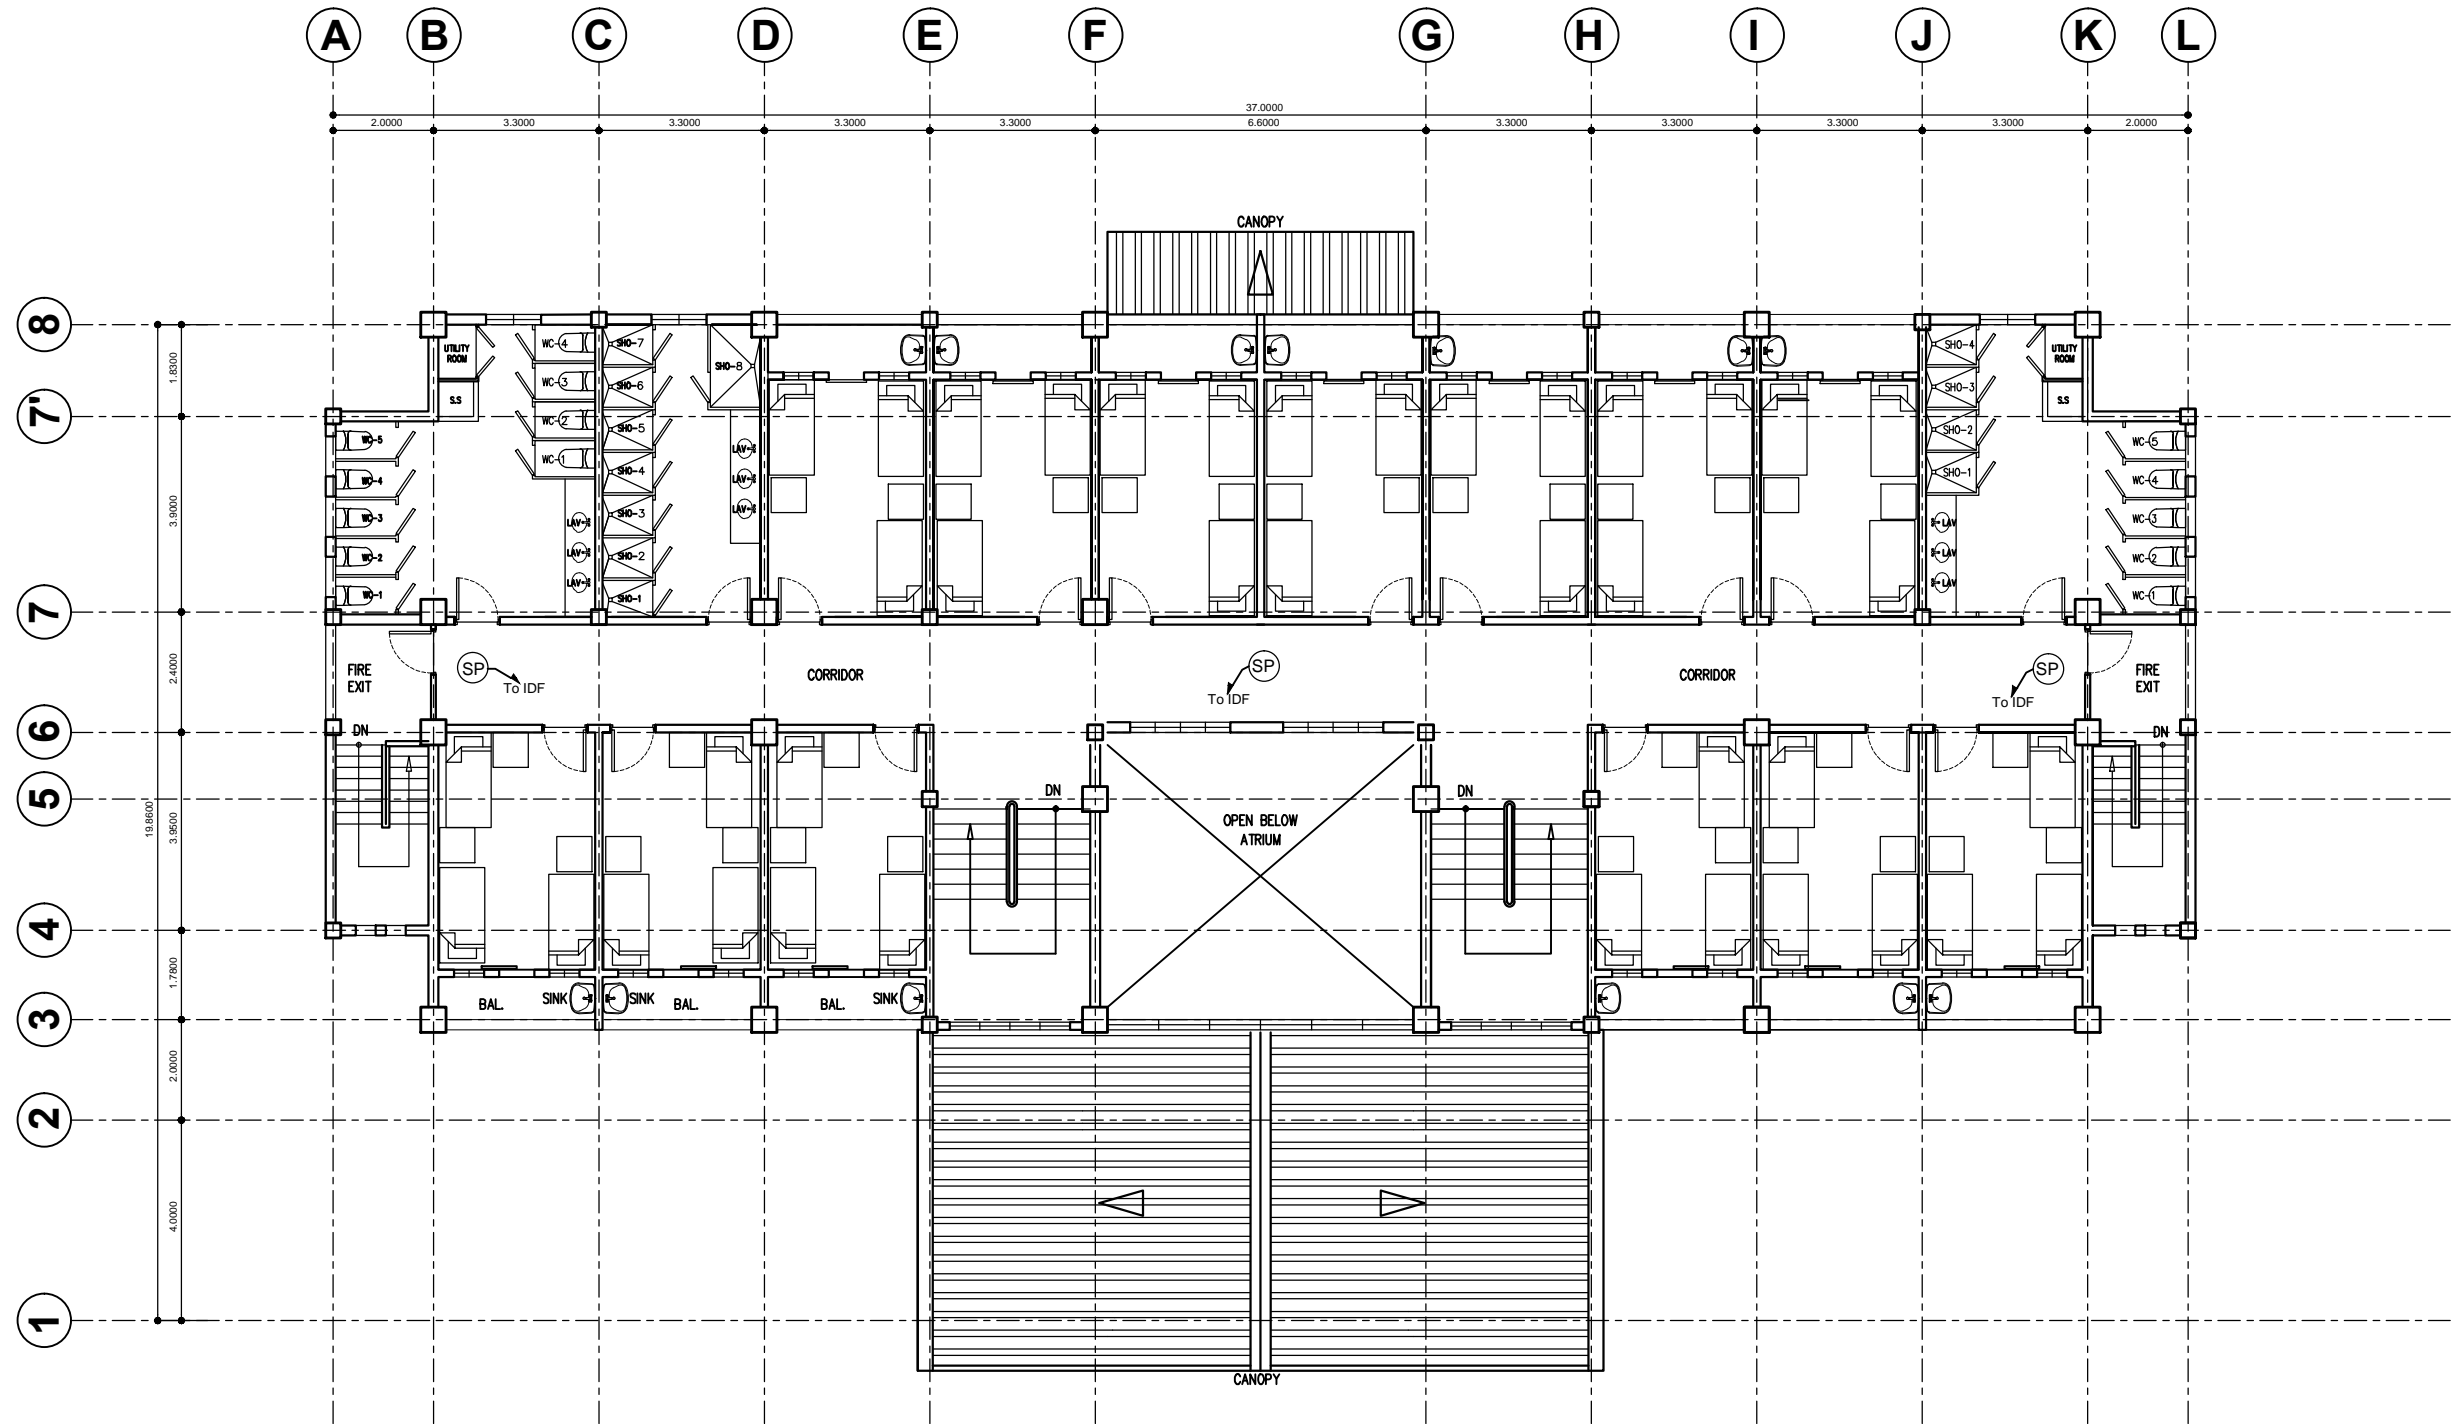


DORMITORY BUILDING II  
**SECOND FLOOR PA BGM LAYOUT**

SCALE

1:150MTS


<b>OWNER:</b>  Republic of the Philippines DEPARTMENT OF SCIENCE AND TECHNOLOGY Philippine Science High School MIMAROPA Region Campus Brgy. Rizal, Odiongan, Romblon 5505	<b>Project Title:</b> <p style="text-align: center;"><b>COMPLETION OF DORMITORY BUILDING II</b></p> Location: Brgy. Rizal, Odiongan Romblon 5505	<b>Prepared by:</b> <p style="text-align: center;"><i>[Signature]</i> <b>PLANNING TEAM</b></p> Date Prepared:	<b>Recommending approval by:</b> <p style="text-align: center;"><i>[Signature]</i> <b>Ivy May F. Famatiga</b> FAD Chief</p> Date:	<b>Approved by:</b> <p style="text-align: center;"><i>[Signature]</i> <b>Romeo C. Ongpoy, Jr.</b> Campus Director</p> Date:	<b>Sheet Content:</b> <p style="text-align: center;">As Shown</p>	<b>Sheet No.</b> <p style="text-align: center;">EC</p> <table border="1" style="width: 100%; text-align: center;"> <tr> <td>2</td> <td>3</td> </tr> </table>	2	3
2	3							

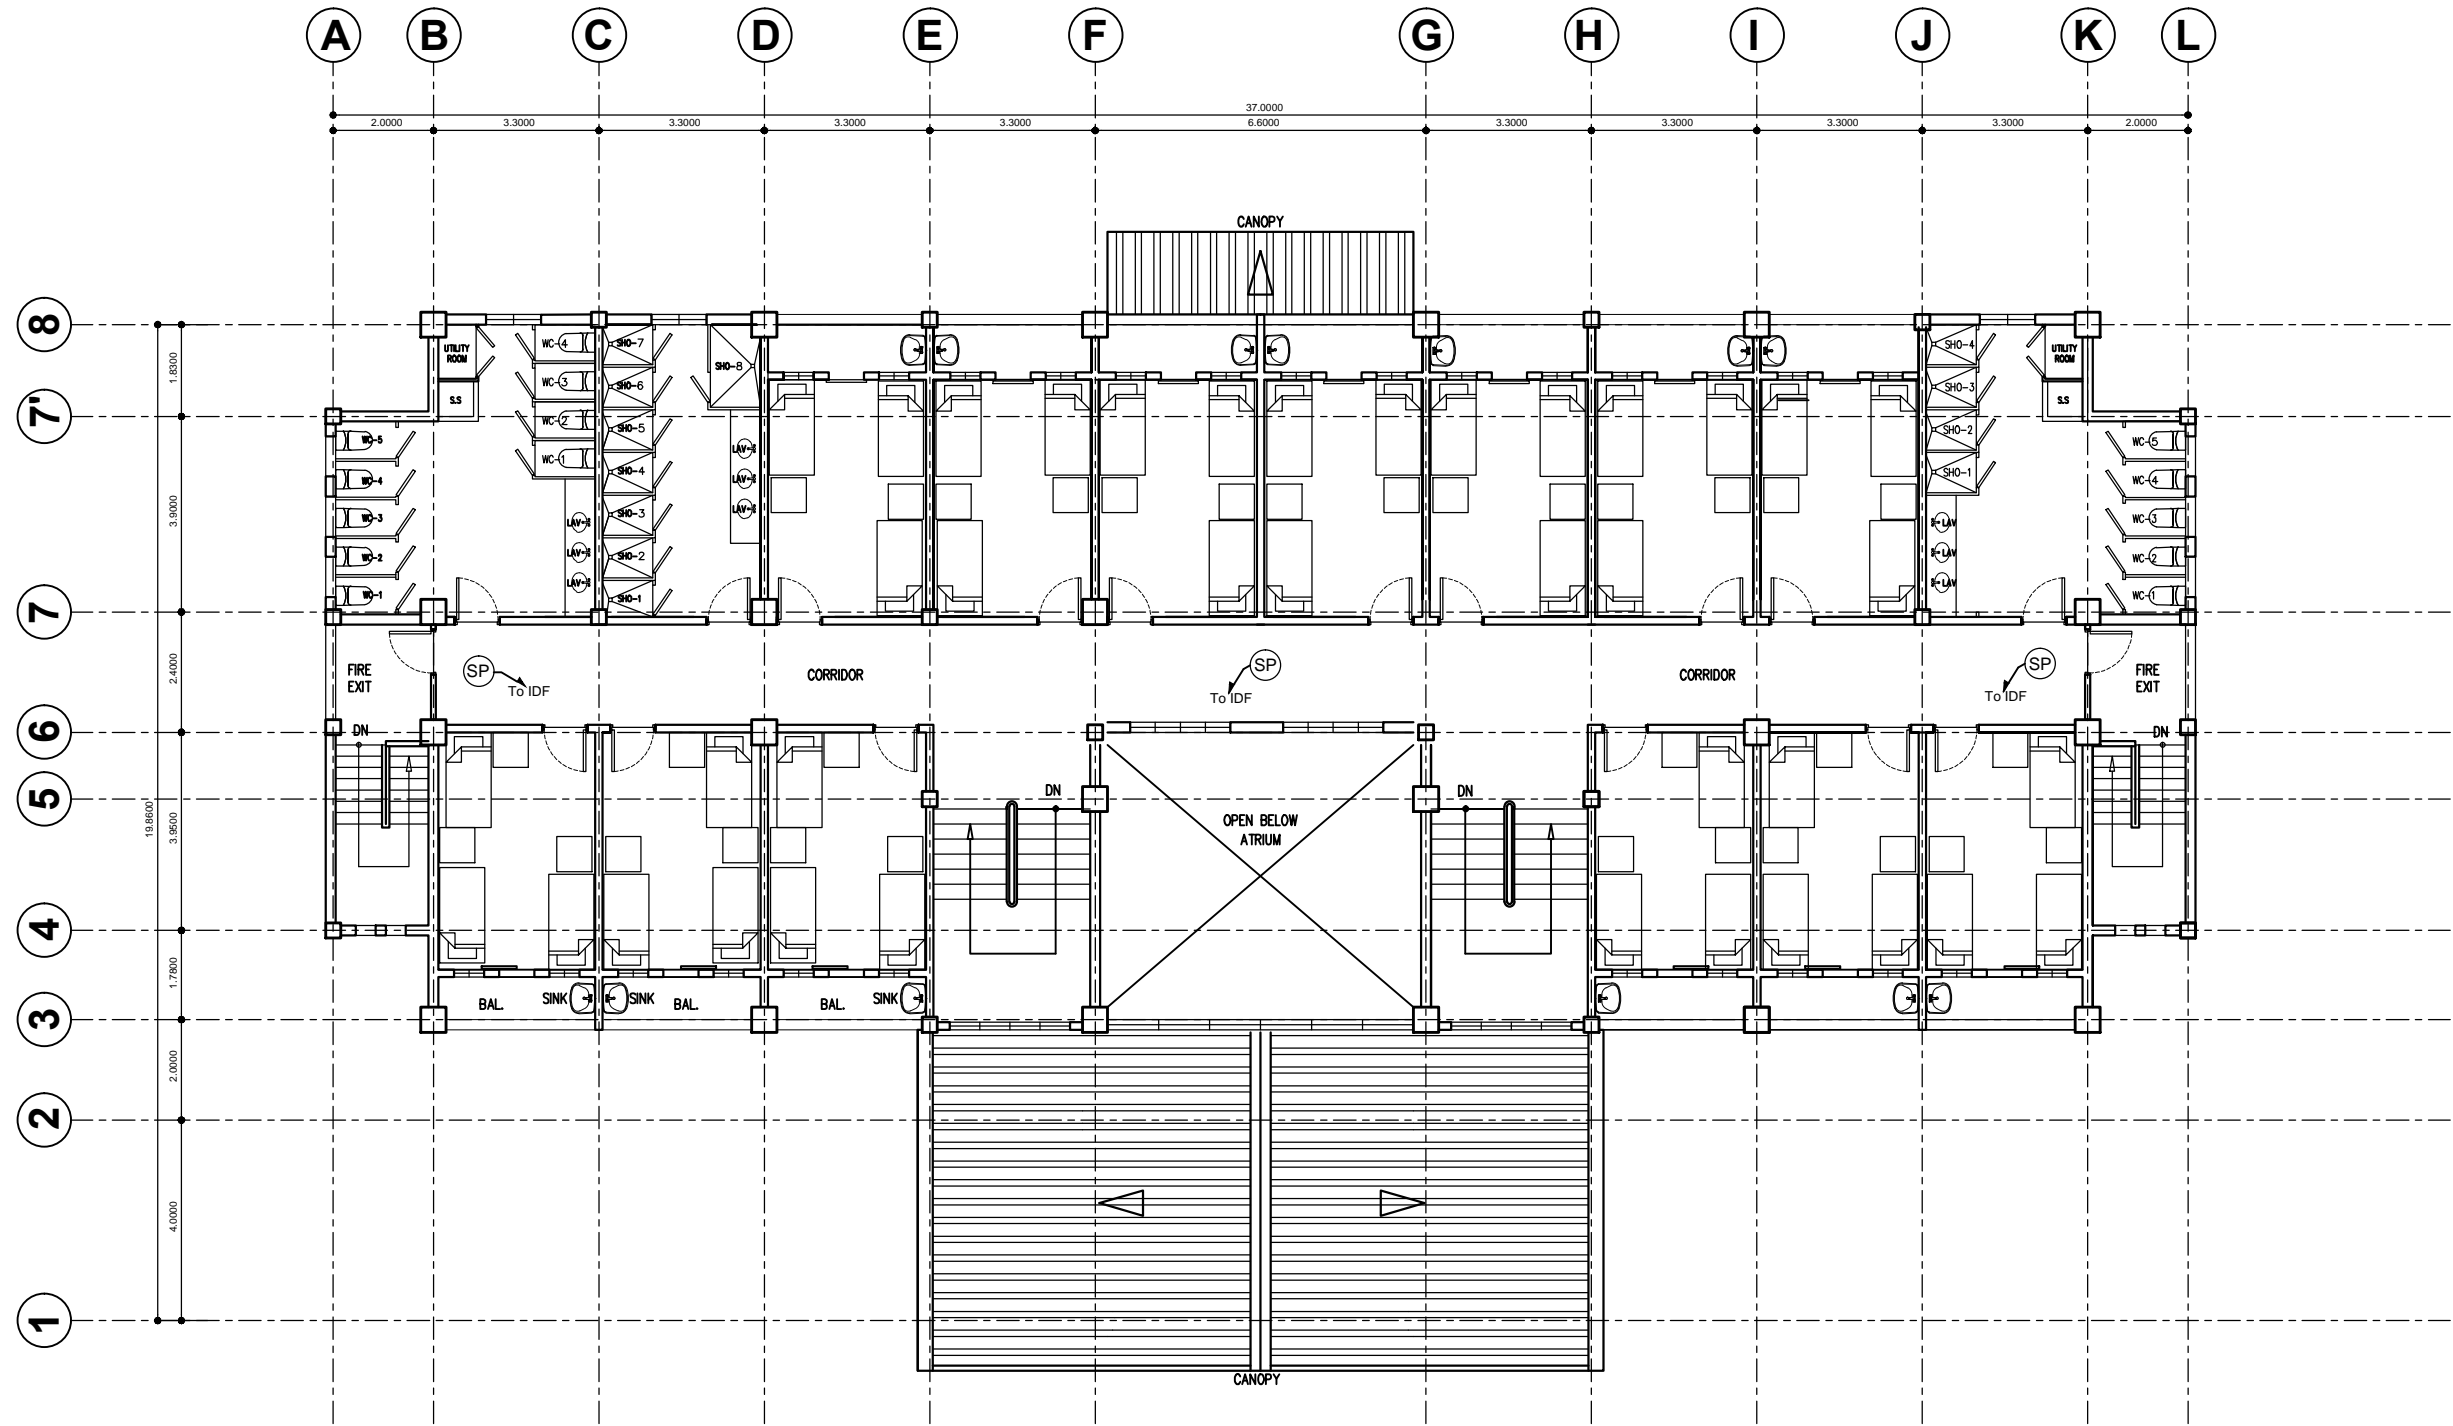

DORMITORY BUILDING II  
**THIRD FLOOR PA BGM LAYOUT**

SCALE

1:150MTS

OWNER:	Project Title:	Prepared by:	Recommending approval by:	Approved by:	Sheet Content:	Sheet No.
 Republic of the Philippines DEPARTMENT OF SCIENCE AND TECHNOLOGY Philippine Science High School MIMAROPA Region Campus Brgy. Rizal, Odiongan, Romblon 5505	<b>COMPLETION OF          DORMITORY BUILDING II</b>  Location: Brgy. Rizal, Odiongan Romblon 5505	PLANNING TEAM  Date Prepared:	Ivy May F. Famatiga FAD Chief  Date:	Romeo C. Ongpoy, Jr. Campus Director  Date:	As Shown	EC 3   3