
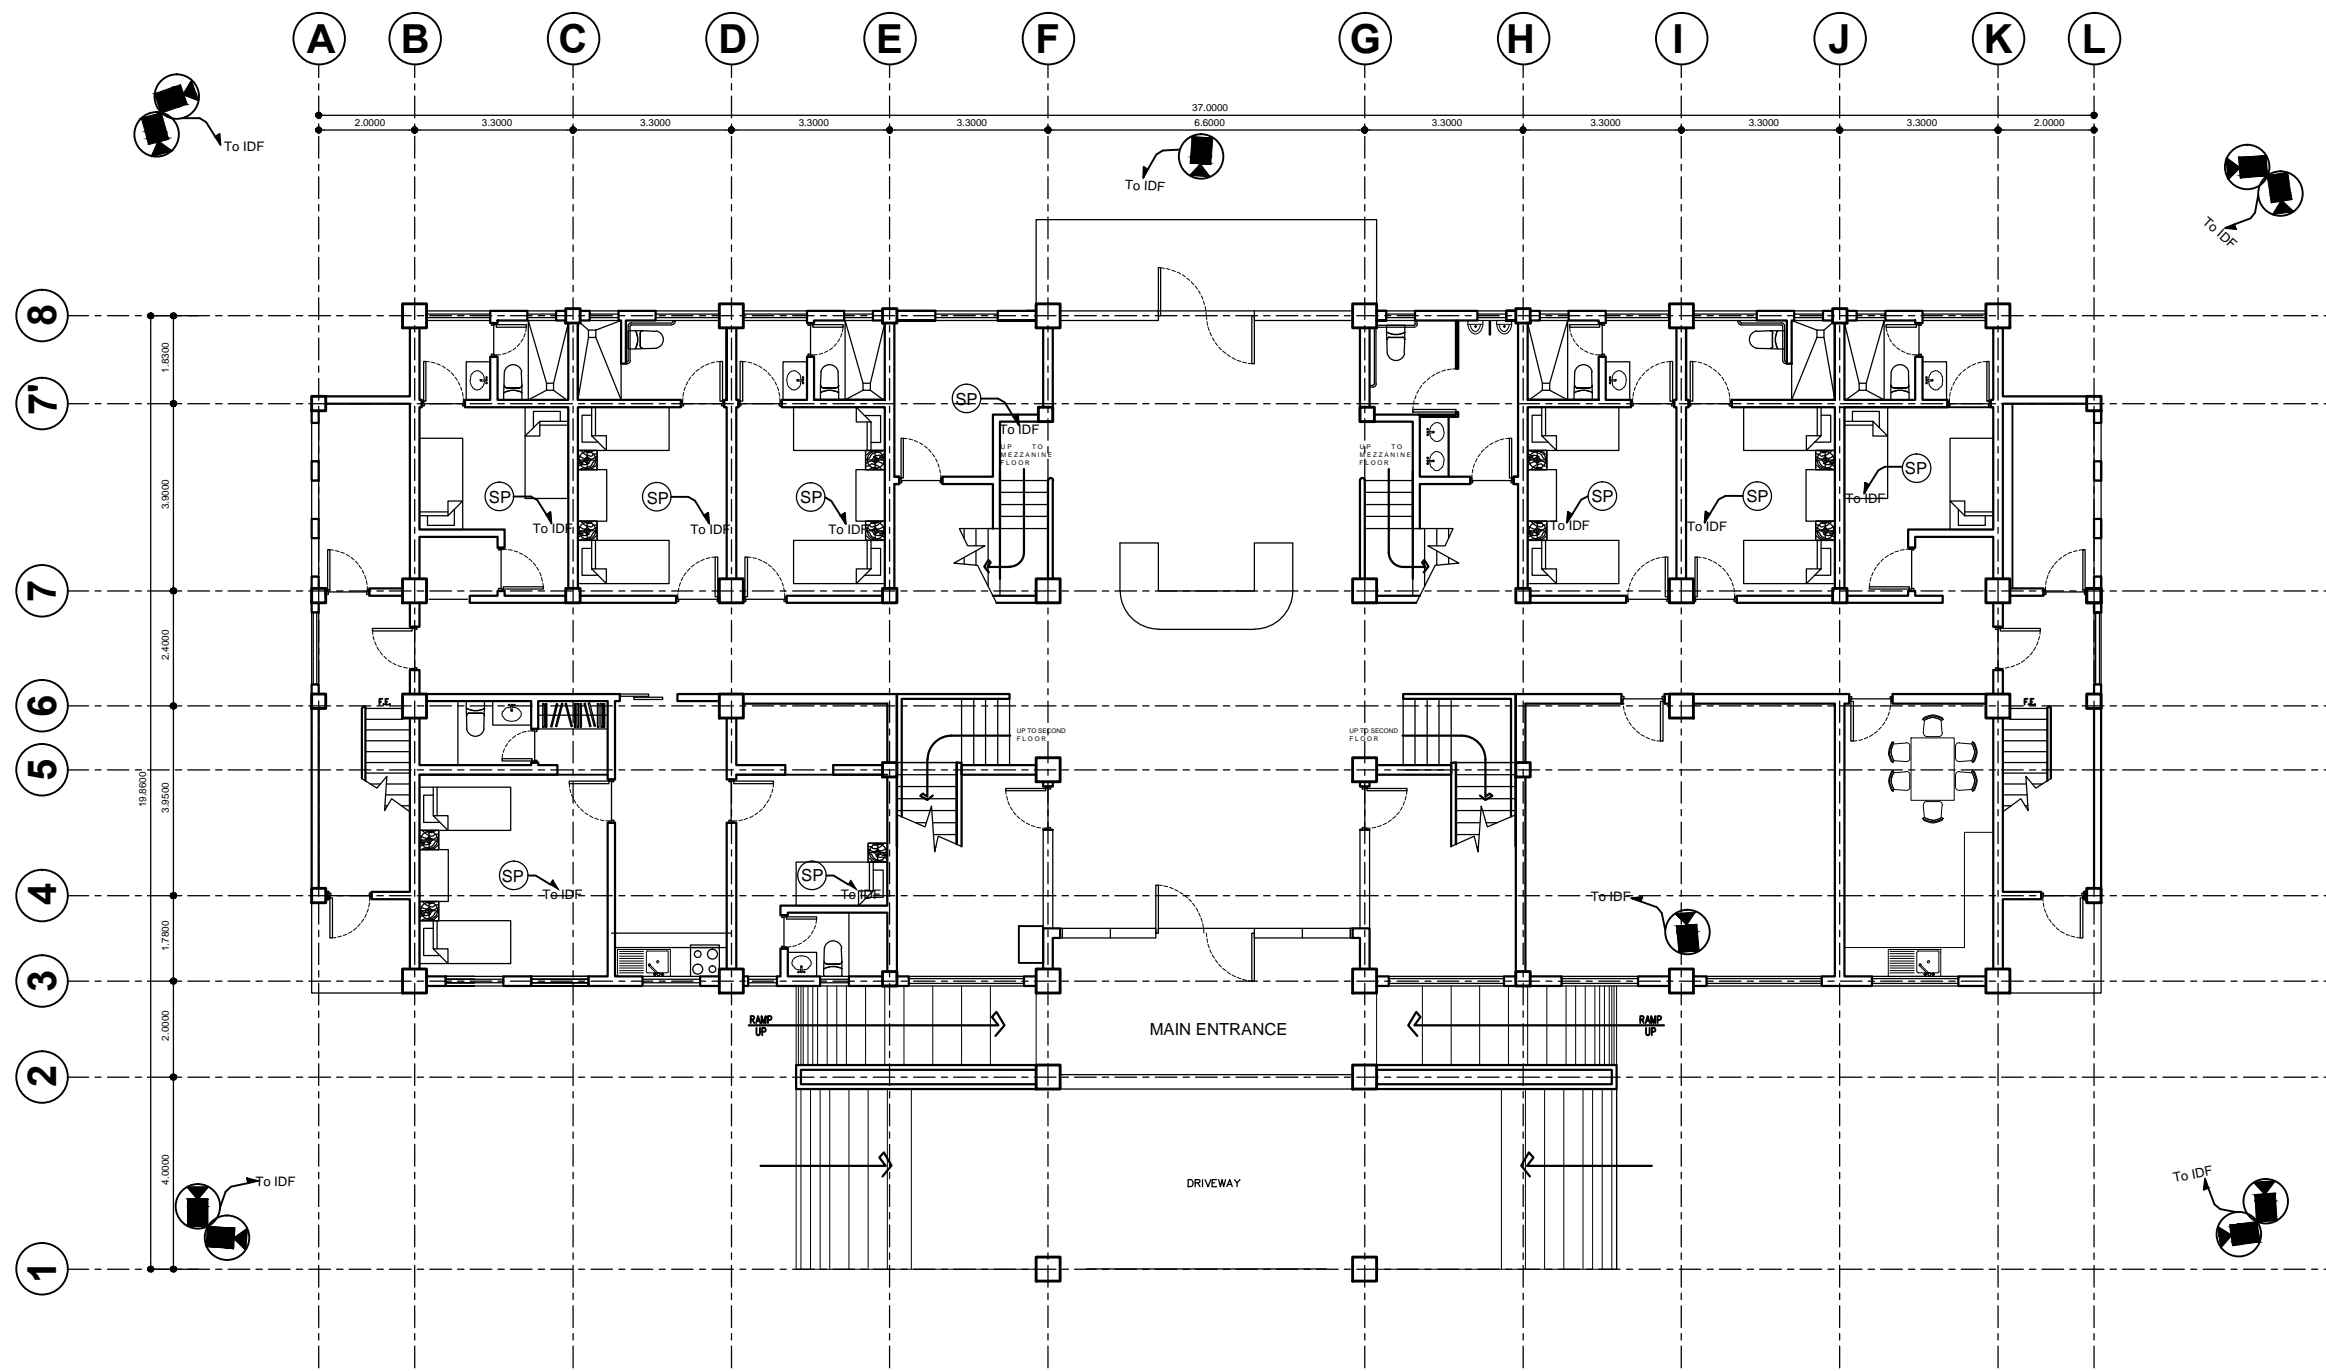


DORMITORY BUILDING II
GROUND FLOOR LIGHTING PLAN

SCALE


1:150MTS


OWNER:	Project Title:	Prepared by:	Recommending approval by:	Approved by:	Sheet Content:	Sheet No.
 Republic of the Philippines DEPARTMENT OF SCIENCE AND TECHNOLOGY Philippine Science High School MIMAROPA Region Campus Brgy. Rizal, Odiongan, Romblon 5505	COMPLETION OF DORMITORY BUILDING II	PLANNING TEAM	Ivy May F. Famatiga FAD Chief	Romeo C. Ongpoy, Jr. Campus Director	As Shown	EE
	Location: Brgy. Rizal, Odiongan Romblon 5505	Date Prepared:	Date:	Date:		2



**DORMITORY BUILDING II
GROUND FLOOR CCTV LAYOUT**

SCALE _____ 1:150MTS


OWNER:	Project Title:	Prepared by:	Recommending approval by:	Approved by:	Sheet Content:	Sheet No.		
 Republic of the Philippines DEPARTMENT OF SCIENCE AND TECHNOLOGY Philippine Science High School MIMAROPA Region Campus Brgy. Rizal, Odiongan, Romblon 5505	COMPLETION OF DORMITORY BUILDING II Location: Brgy. Rizal, Odiongan Romblon 5505	PLANNING TEAM Date Prepared:	Ivy May F. Famatiga FAD Chief Date:	Romeo C. Ongpoy, Jr. Campus Director Date:	As Shown	EC <table border="1" style="width: 100%; text-align: center;"> <tr> <td style="width: 50%;">1</td> <td style="width: 50%;">3</td> </tr> </table>	1	3
1	3							

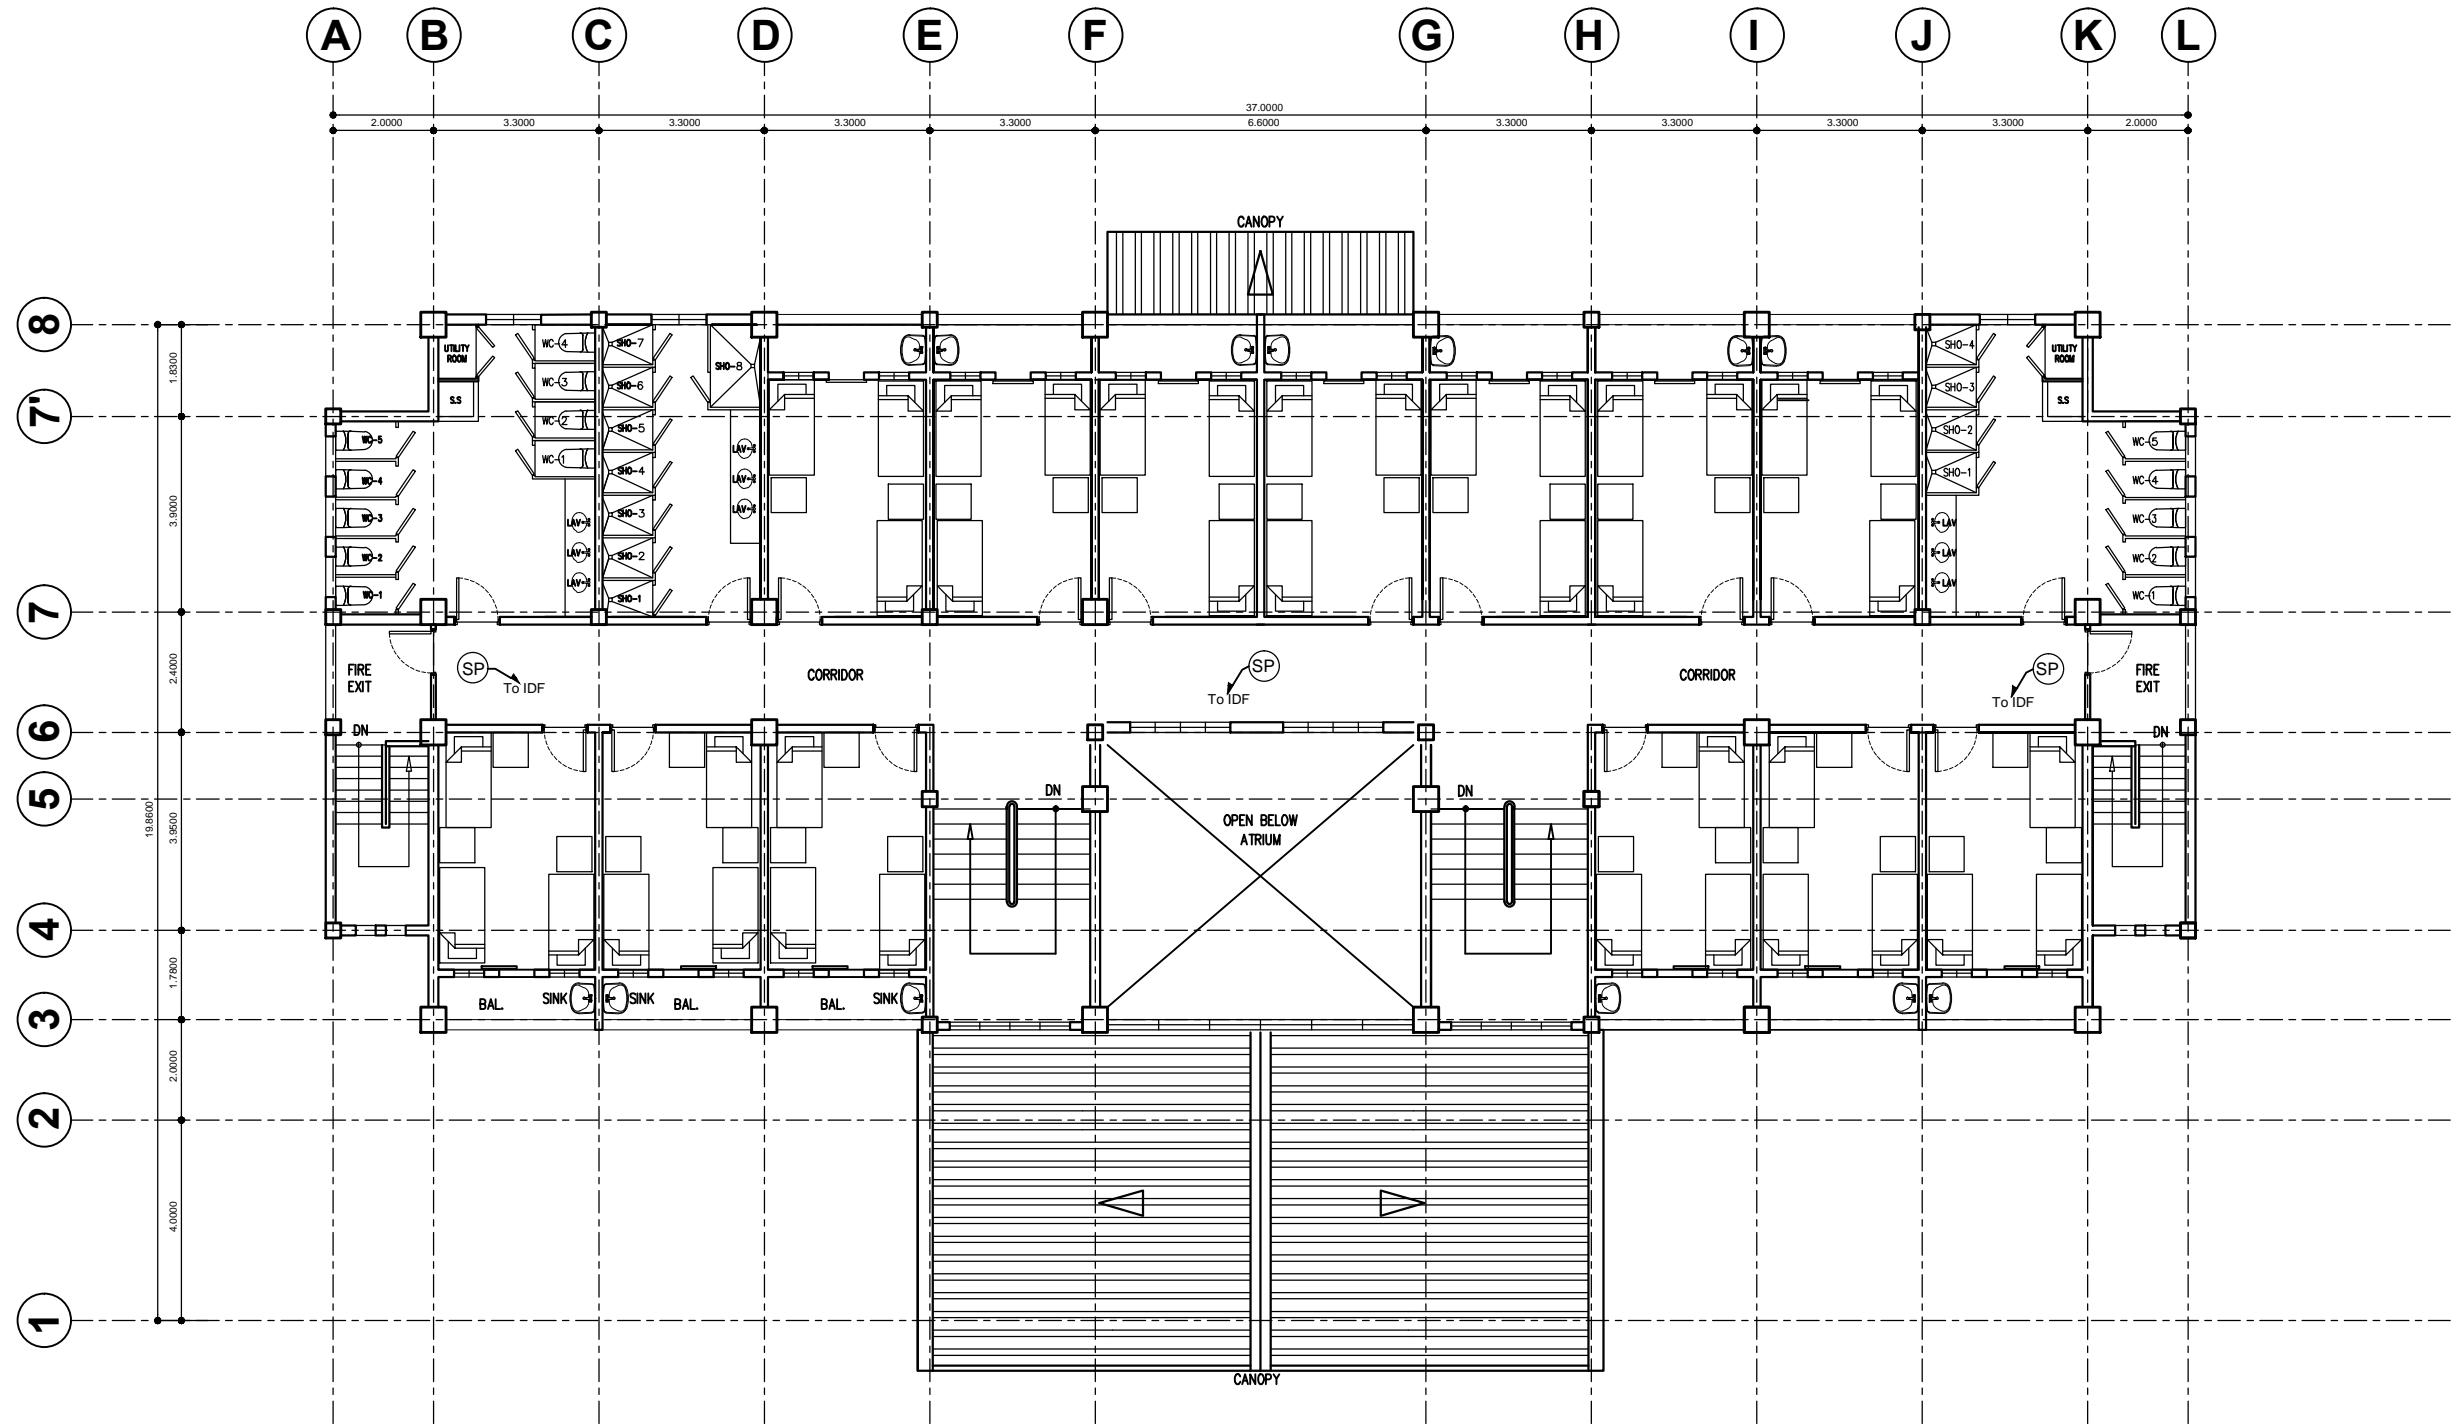


DORMITORY BUILDING II
SECOND FLOOR PA BGM LAYOUT

SCALE

1:150MTS


OWNER:	Project Title:	Prepared by:	Recommending approval by:	Approved by:	Sheet Content:	Sheet No.
 Republic of the Philippines DEPARTMENT OF SCIENCE AND TECHNOLOGY Philippine Science High School MIMAROPA Region Campus Brgy. Rizal, Odiongan, Romblon 5505	COMPLETION OF DORMITORY BUILDING II Location: Brgy. Rizal, Odiongan Romblon 5505	PLANNING TEAM Date Prepared:	Ivy May F. Famatiga FAD Chief Date:	Romeo C. Ongpoy, Jr. Campus Director Date:	As Shown	EC 2 3

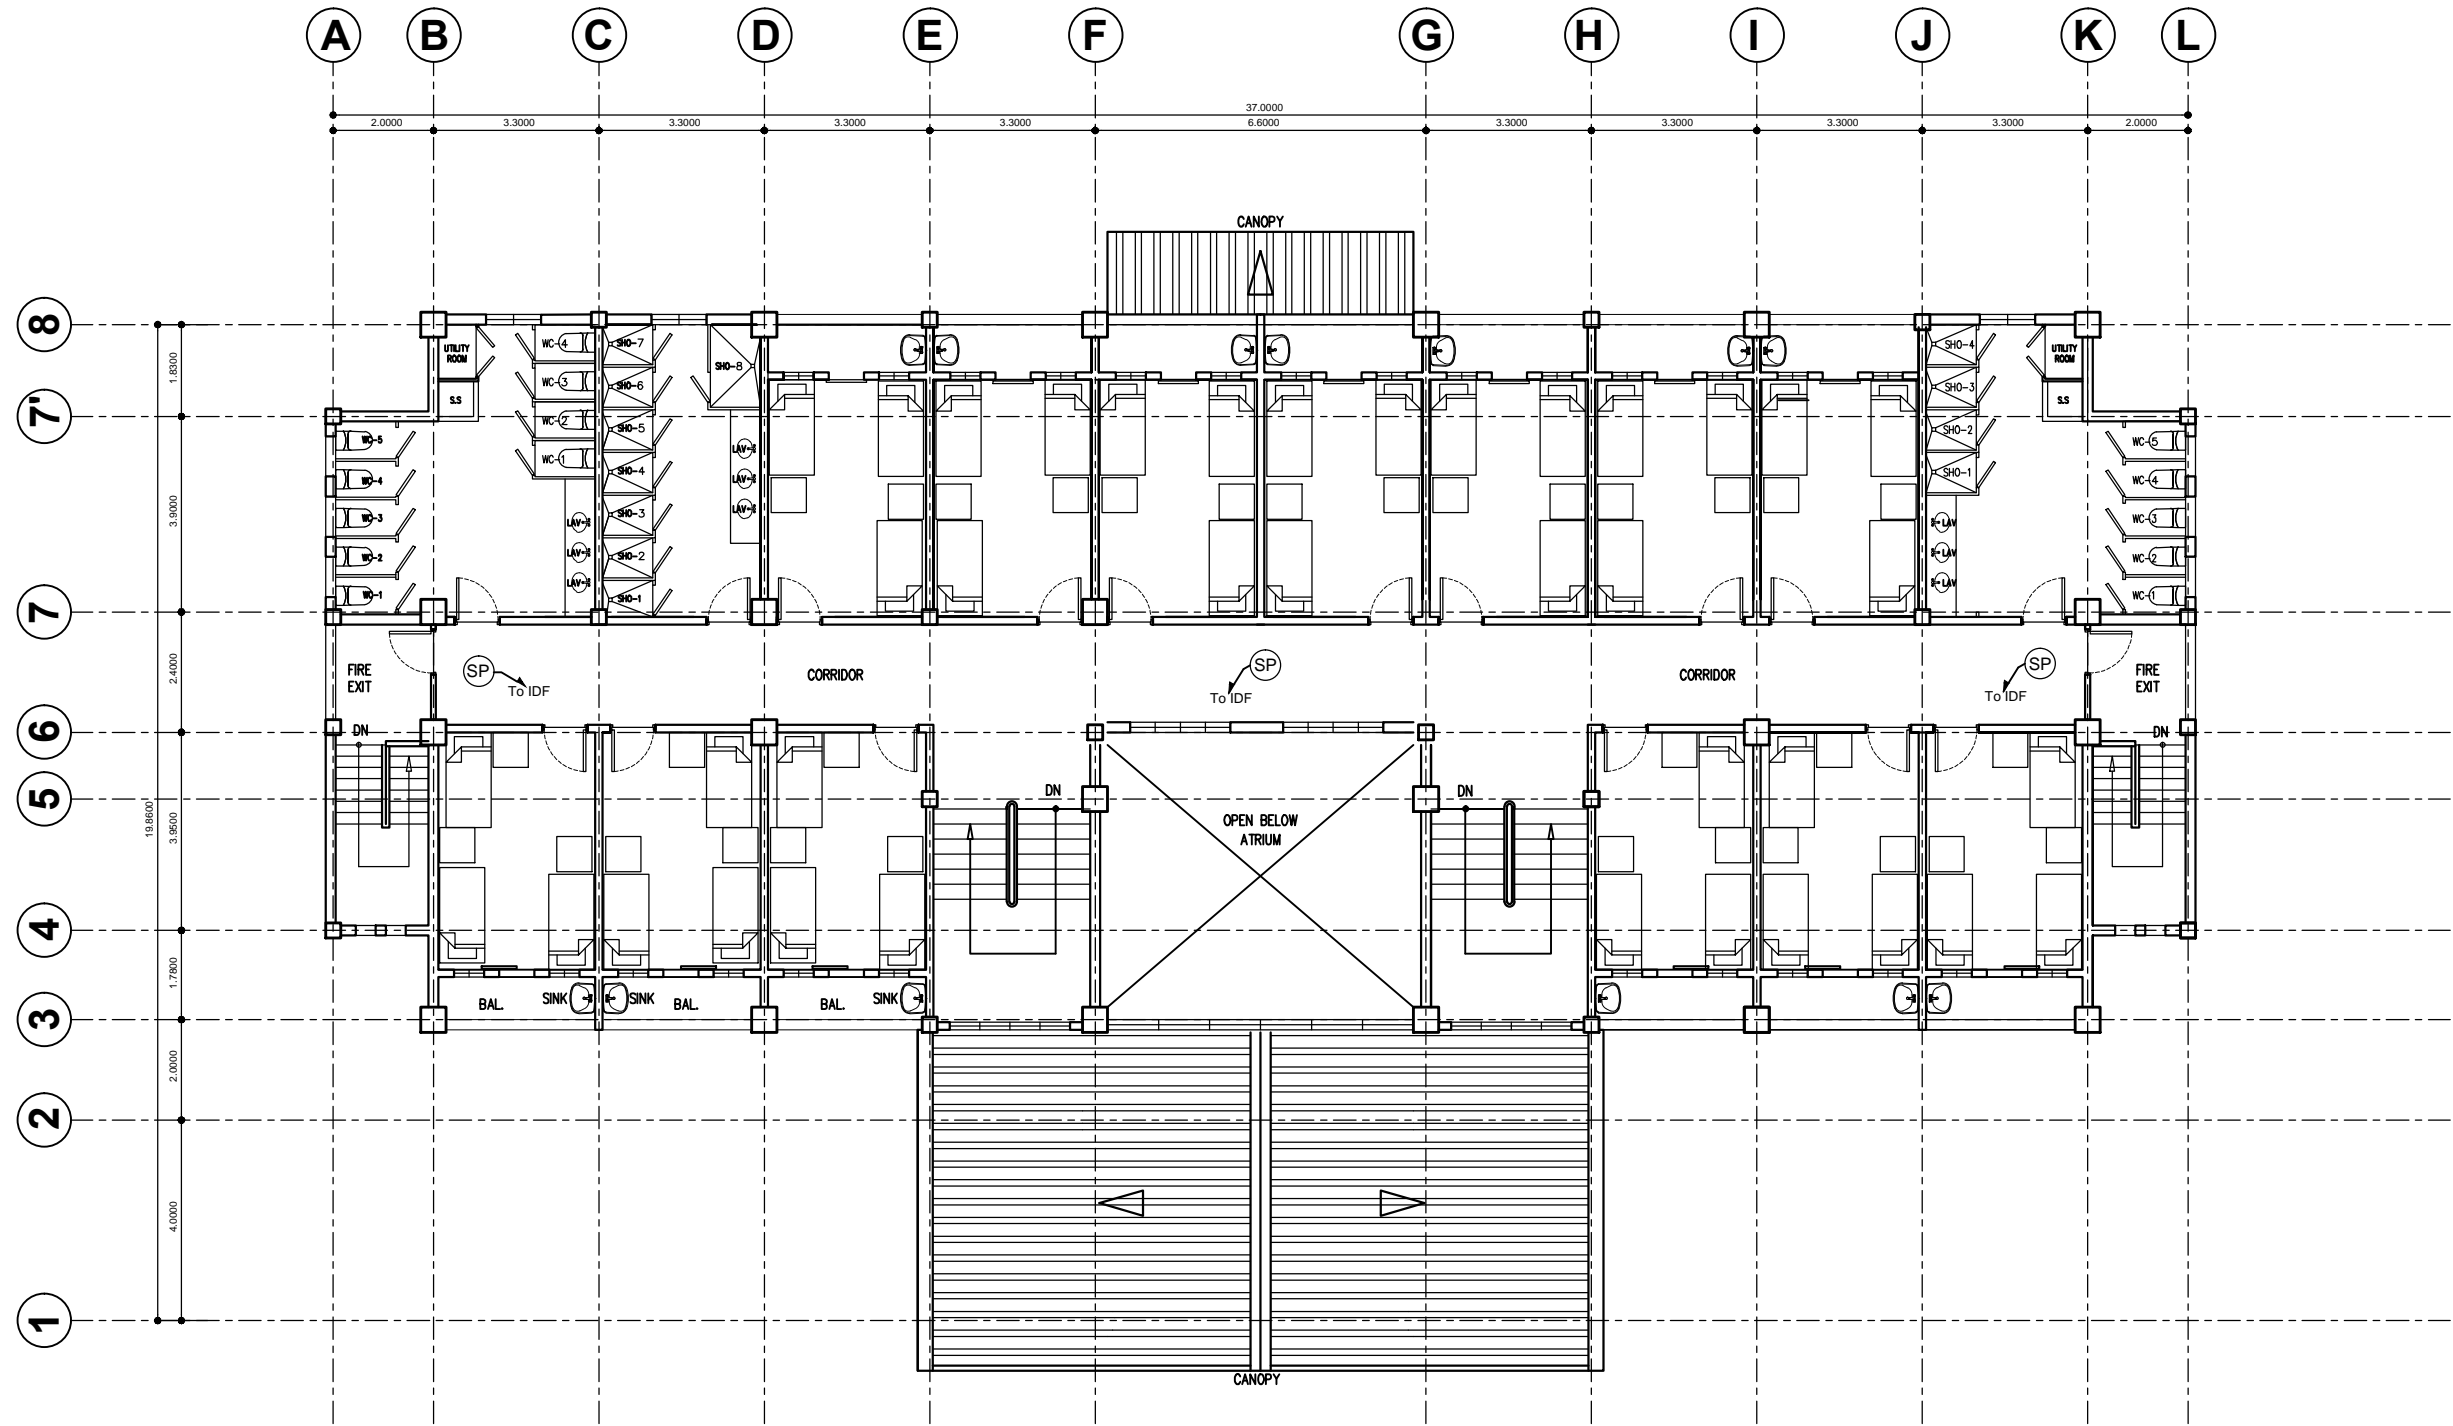

DORMITORY BUILDING II
THIRD FLOOR PA BGM LAYOUT

SCALE

1:150MTS

OWNER:	Project Title:	Prepared by:	Recommending approval by:	Approved by:	Sheet Content:	Sheet No.
 Republic of the Philippines DEPARTMENT OF SCIENCE AND TECHNOLOGY Philippine Science High School MIMAROPA Region Campus Brgy. Rizal, Odiongan, Romblon 5505	COMPLETION OF DORMITORY BUILDING II Location: Brgy. Rizal, Odiongan Romblon 5505	PLANNING TEAM Date Prepared:	Ivy May F. Famatiga FAD Chief Date:	Romeo C. Ongpoy, Jr. Campus Director Date:	As Shown	EC 3 3