



PERSPECTIVE PLAN

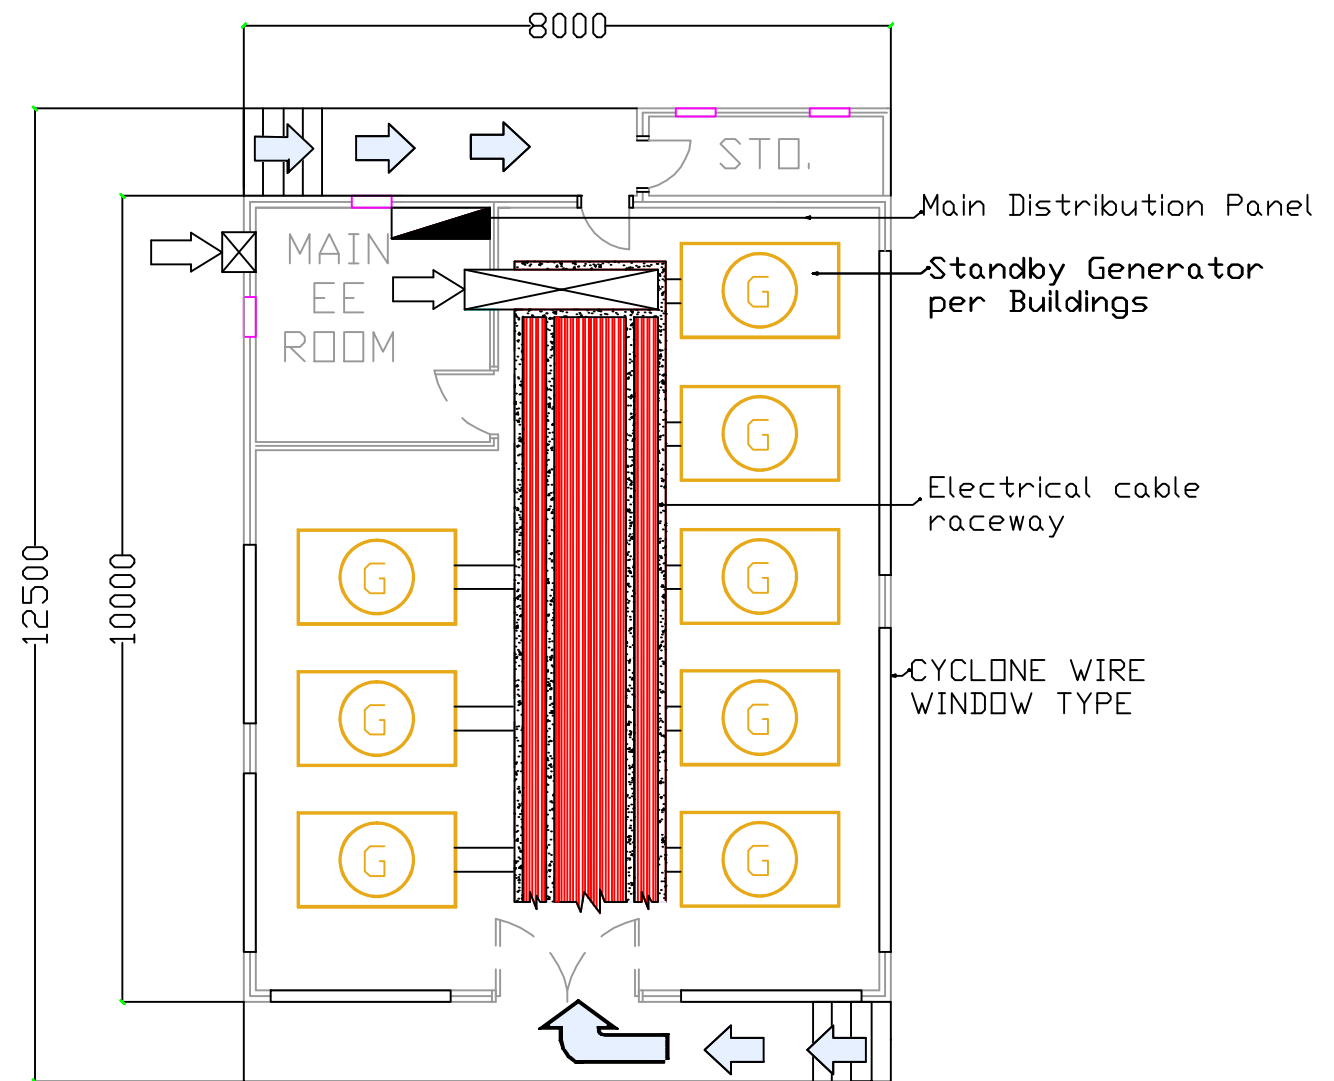

FLOOR PLAN

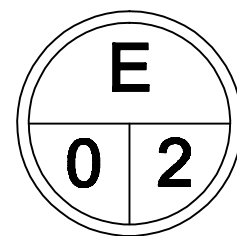

MAIN POWERHOUSE CONCEPT
 PERSPECTIVE & FLOOR PLAN
 SCALE NTS

ARCHITECT: JOLITO G. TAN REGISTERED & LICENSED ARCHITECT		PROJECT TITLE: CONSTRUCTION OF ELECTRICAL DISTRIBUTION SYSTEM (WITH GENSET AND 2 TRANSFORMERS)		REPUBLIC OF THE PHILIPPINES DEPARTMENT OF SCIENCE AND TECHNOLOGY PHILIPPINE SCIENCE HIGH SCHOOL MIMAROPA REGION CAMPUS BRGY. RIZAL, ODIONGAN, ROMBLON		APPROVED: EDWARD C. ALBARACIN CAMPUS DIRECTOR		SHEET CONTENTS MAIN POWERHOUSE PERSPECTIVE & FLOOR PLAN DESIGN CONCEPT		SHEET NO. E 0 2	
PRC NO.: 18228 PTR NO.: 3804228 TIN NO.: 128-716-446	ISSUED ON: 11-09-76 ISSUED ON: 01-05-17 ISSUED AT: QUEZON CITY	LOCATION: MIMAROPA REGION CAMPUS, ODIONGAN, ROMBLON		<small>THIS DOCUMENT IS AN INSTRUMENT OF PROFESSIONAL SERVICE AND AS SUCH MAY NOT BE REPRODUCED IN WHOLE OR IN PART WITHOUT THE WRITTEN CONSENT OF THE ARCHITECT. -P.A. 545</small>							